
 
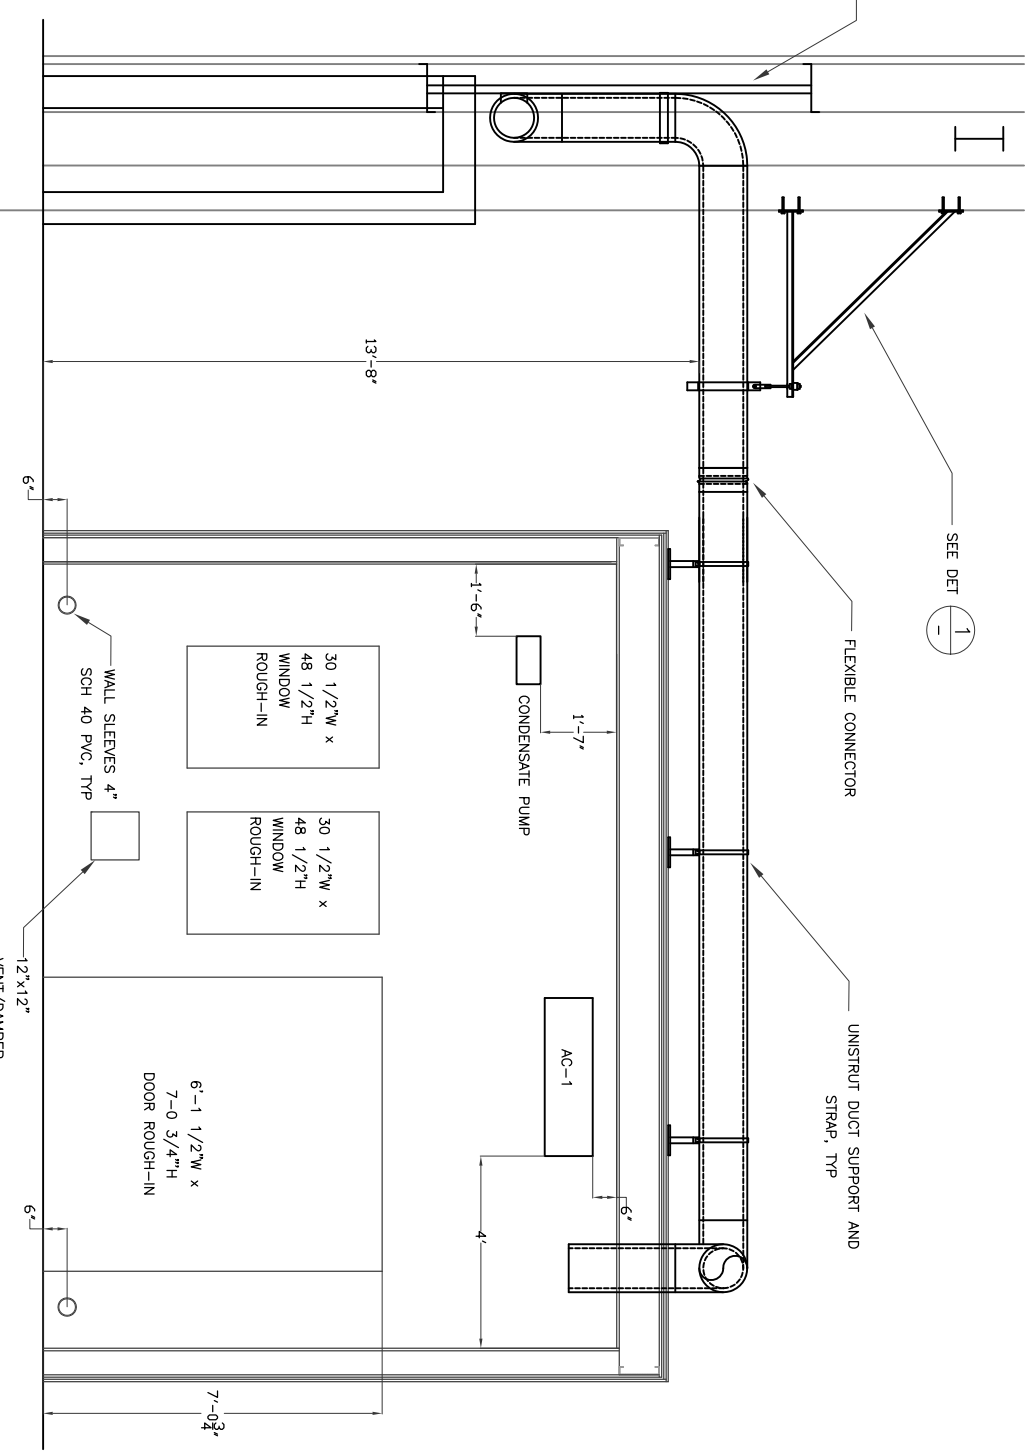
 



A
2392
LAE WALL SECTION
SCALE: 1/2" = 1'-0"

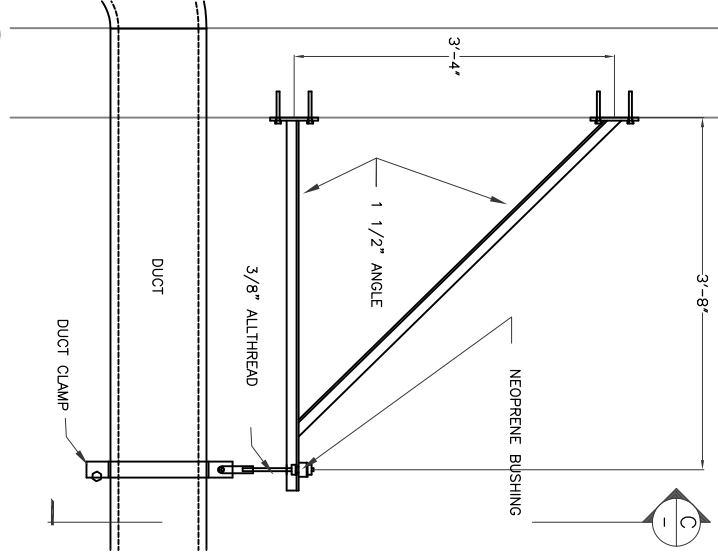

B
2392
LAE WALL SECTION
SCALE: 1/2" = 1'-0"



1
DUCT SUPPORT DETAIL
SCALE: 1" = 1'-0"

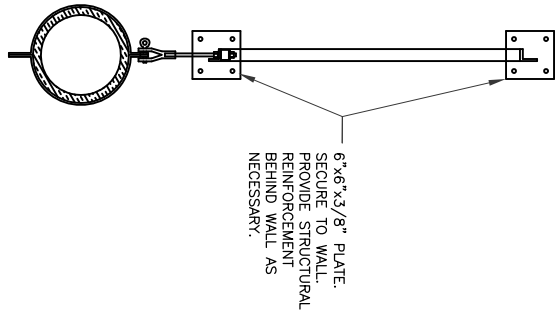

C
DUCT SUPPORT SECTION
SCALE: 1" = 1'-0"

DRAWING: LIGO-D1002393-V1

PRINTED BY: GJ on 9/13/2010 9:06 AM

CALIFORNIA INSTITUTE OF TECHNOLOGY
LIGO LIVINGSTON OBSERVATORY
HIBBS ENGINEERING, INC.
KENNEWICK, WASHINGTON

DRAWING NUMBER	2393
REV	V1

L1 LASER AREA ENCLOSURE
MECHANICAL
SECTIONS & DETAILS

PROJECT NUMBER:	1036.01	CAD FILE:	1036M01
-----------------	---------	-----------	---------

© 2010 Hibbs Engineering, Inc.

DRAWN BY:	GLH
CHECKED BY:	
DESIGN A/E	DESIGN GM
HEI APPROVAL	

REV No	DATE	BY	DESCRIPTION	APPROVED

DATE OF ISSUE