


NOTES:
 1. SEE SHEET WA-C-002 FOR GENERAL NOTES, LEGEND AND ABBREVIATIONS.
 2. GRADING BY OTHERS.

This document and the design it covers are the property of **PARSONS**. They are loaned only with the borrower's expressed written agreement that they will not be reproduced, copied, loaned, exhibited, or used in any other way, except by written consent from **PARSONS** to the borrower.

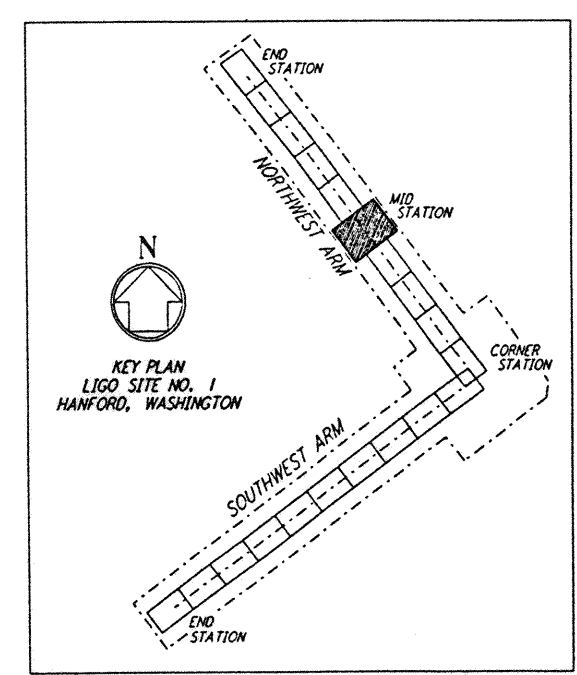

NO.	DATE	BY	CHKD	ENGR	PROJ	DESCRIPTION
B	4/19/96	WRB	JJA	TD	TD	FINAL DESIGN REVIEW & BID
A	10/31/95	WRB	TOM			PRELIMINARY DESIGN REVIEW

DRW	WRB
CHKD	
ENGR	
PROJ	

PARSONS
 100 WEST WALNUT STREET
 PASADENA, CALIFORNIA

LIGO
 CALIFORNIA INSTITUTE OF TECHNOLOGY
 MASSACHUSETTS INSTITUTE OF TECHNOLOGY

LASER INTERFEROMETER
 GRAVITATIONAL-WAVE OBSERVATORY
 SITE NO. 1 - HANFORD, WASHINGTON

TITLE: CIVIL NORTHWEST ARM MID-STATION GRADING PLAN

SCALE: 1" = 20'

CONTRACT NUMBER: PP150969

PROJECT NUMBER: 8094

SHEET NUMBER: **WA-C-022**

LIGO-D960213-B-11