 



CLEAN AGENT FIRE SUPPRESSION SYSTEM STORAGE CONTAINERS SEE NOTES  
 CLEAN AGENT FIRE SUPPRESSION SYSTEM PANEL

- NOTES:**
- A CLEAN AGENT FIRE SUPPRESSION SYSTEM SHALL BE PROVIDED ABOVE AND WITHIN THE DEPRESSED FLOOR SPACE, FOR THE FOLLOWING ROOMS:  
 A. FACILITY CONTROL ROOM [162]  
 B. TAPE & COMPUTER MASS STORAGE ROOM [165]  
 C. COMPUTER USERS ROOM [161]  
 D. GENERAL COMPUTING [163]
  - REFER TO THE PERFORMANCE TYPE SPECIFICATIONS FOR REQUIREMENTS AND DESIGN CRITERIA.

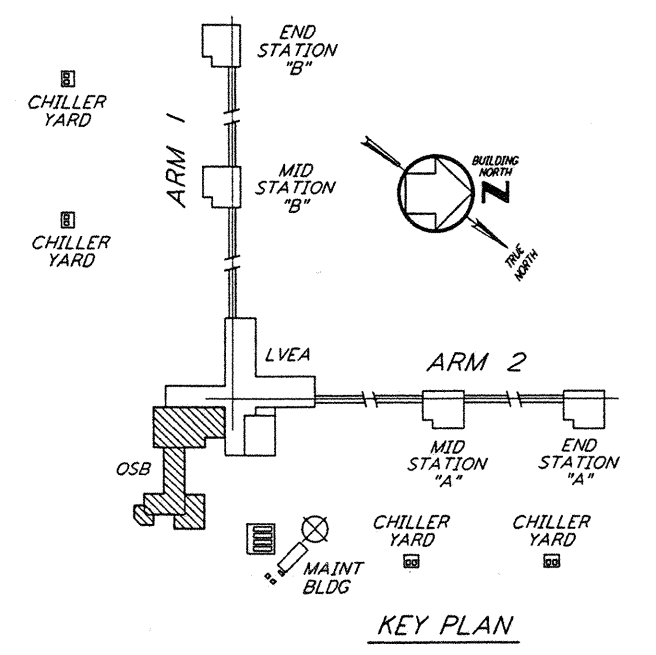

L1G0-D960441-C-0

LASER INTERFEROMETER  
 GRAVITATIONAL-WAVE OBSERVATORY  
 SITE NO. 1 - HANFORD, WASHINGTON

TITLE: PLUMBING CORNER STATION OSB FLOOR PLAN  
 SCALE: AS NOTED  
 CONTRACT NUMBER: PPI50969  
 PROJECT NUMBER: 8094  
 SHEET NUMBER: WA-P-112

NO.	DATE	BY	CHKD	ENGR	PROJ	DESCRIPTION
C	5-22-96	CLP	W.R.	M.N.	T.D.M.	BID ADDENDUM #2
B	4-19-96	DG	MP	MN	TDM	FINAL DESIGN REVIEW & BID
A	10-31-95	SG	MP	MN	TDM	PRELIMINARY DESIGN REVIEW

DRAWN	DG
CHECKED	
ENGINEER	
PROJ	

**PARSONS**  
 100 WEST WALNUT STREET  
 PASADENA, CALIFORNIA

**LIGO**  
 CALIFORNIA INSTITUTE OF TECHNOLOGY  
 MASSACHUSETTS INSTITUTE OF TECHNOLOGY