



AIR HANDLING UNIT STRUCTURE
FOUNDATION PLAN
 1/8" = 1'-0"

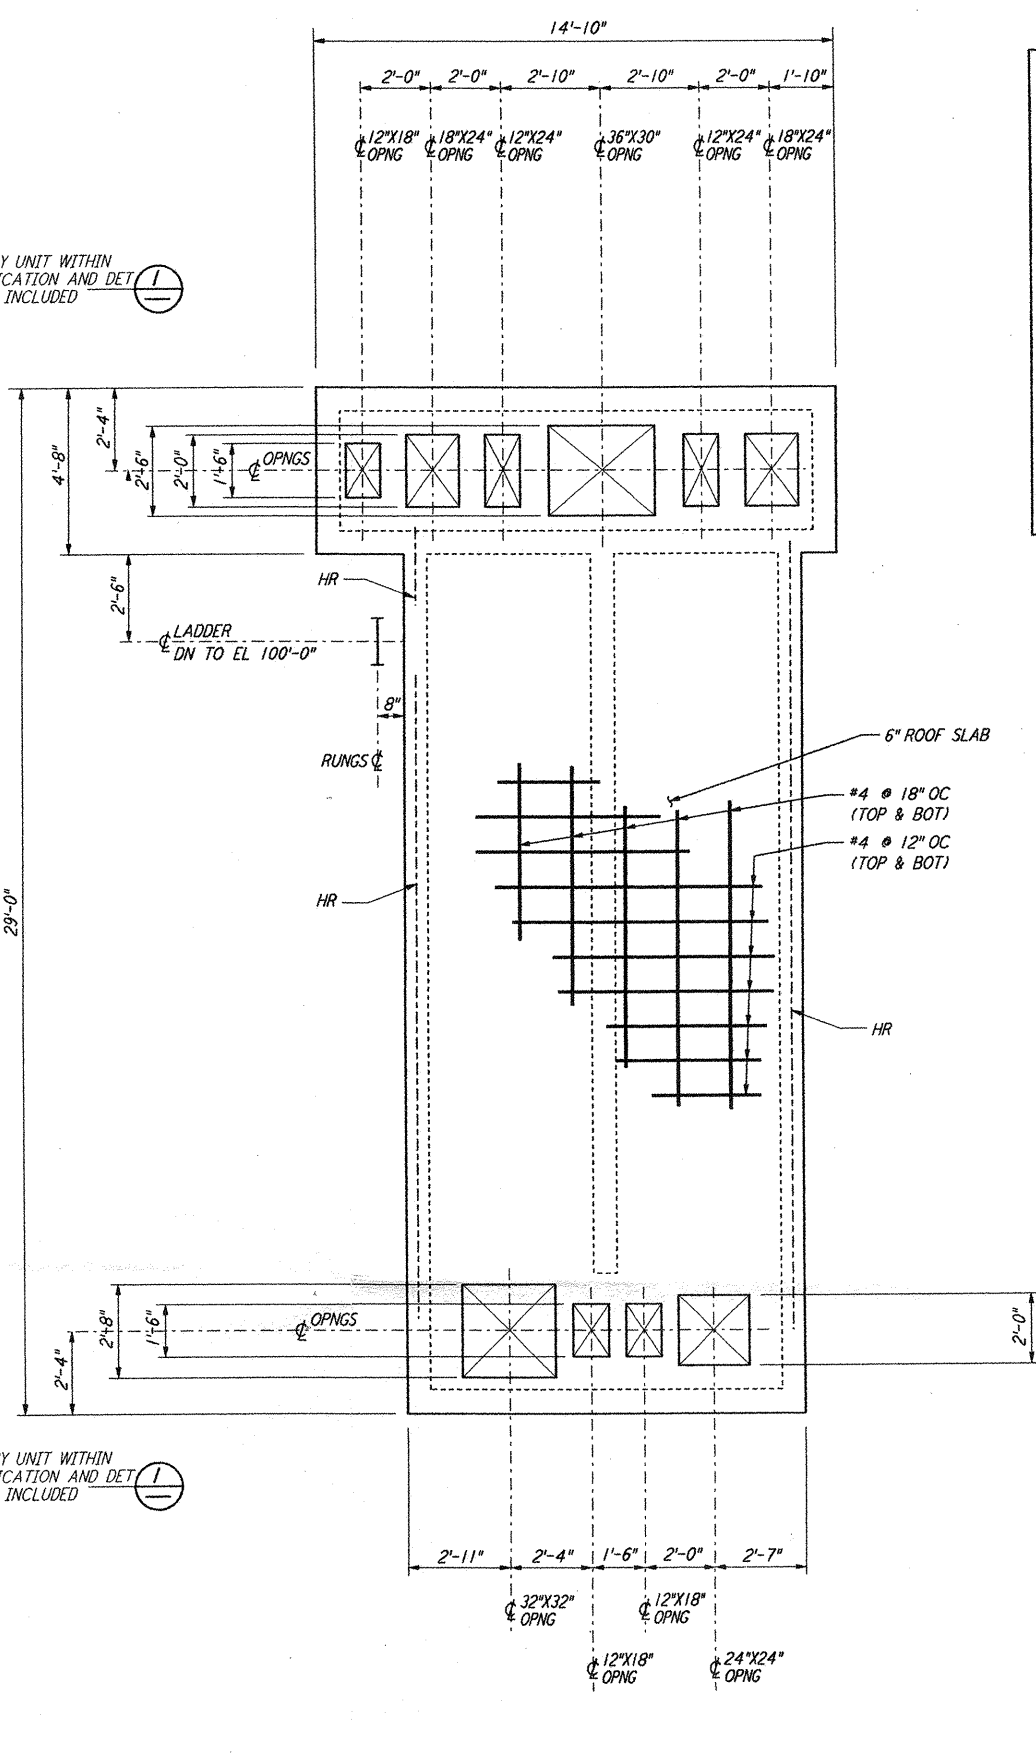

AIR HANDLING UNIT STRUCTURE
CONCRETE ROOF SLAB PLAN
 1/8" = 1'-0"

 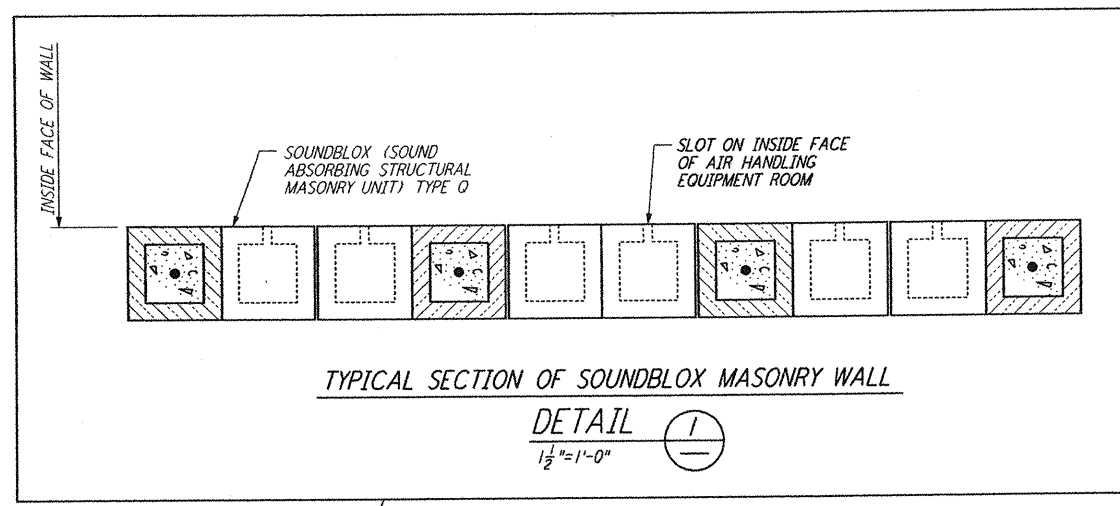


TYPICAL SECTION OF SOUNDBOLY MASONRY WALL
DETAIL 1
 1/2" = 1'-0"

NOT INCLUDED IN THIS CONTRACT

NOT INCLUDED IN THIS CONTRACT

LIGO-D960739-00-0



NO.	DATE	BY	CHKD	ENGR	PROJ	DESCRIPTION
0	1-22-99	MET	--	--	MDW	ISSUED FOR AS BUILT
A	4-19-96	MCS	KS	BP		CHANGE ORDER #4

DRAWN	MCS
CHECKED	
ENGINEER	
PROJ	

AS-BUILT DRAWINGS

PARSONS
 100 WEST WALNUT STREET
 PASADENA, CALIFORNIA

LIGO
 CALIFORNIA INSTITUTE OF TECHNOLOGY
 MASSACHUSETTS INSTITUTE OF TECHNOLOGY

LASER INTERFEROMETER
 GRAVITATIONAL-WAVE OBSERVATORY
 BTE SITEWORK & FABRICATION - HANFORD, WA

STRUCTURAL
 MID & END STATIONS "B"
 AIR HANDLING UNIT
 ENCLOSURE PLANS

AS NOTED
 SHEET NUMBER
BT-S-605

PROJECT NUMBER
 PP150969
 PROJECT NUMBER
 8094