

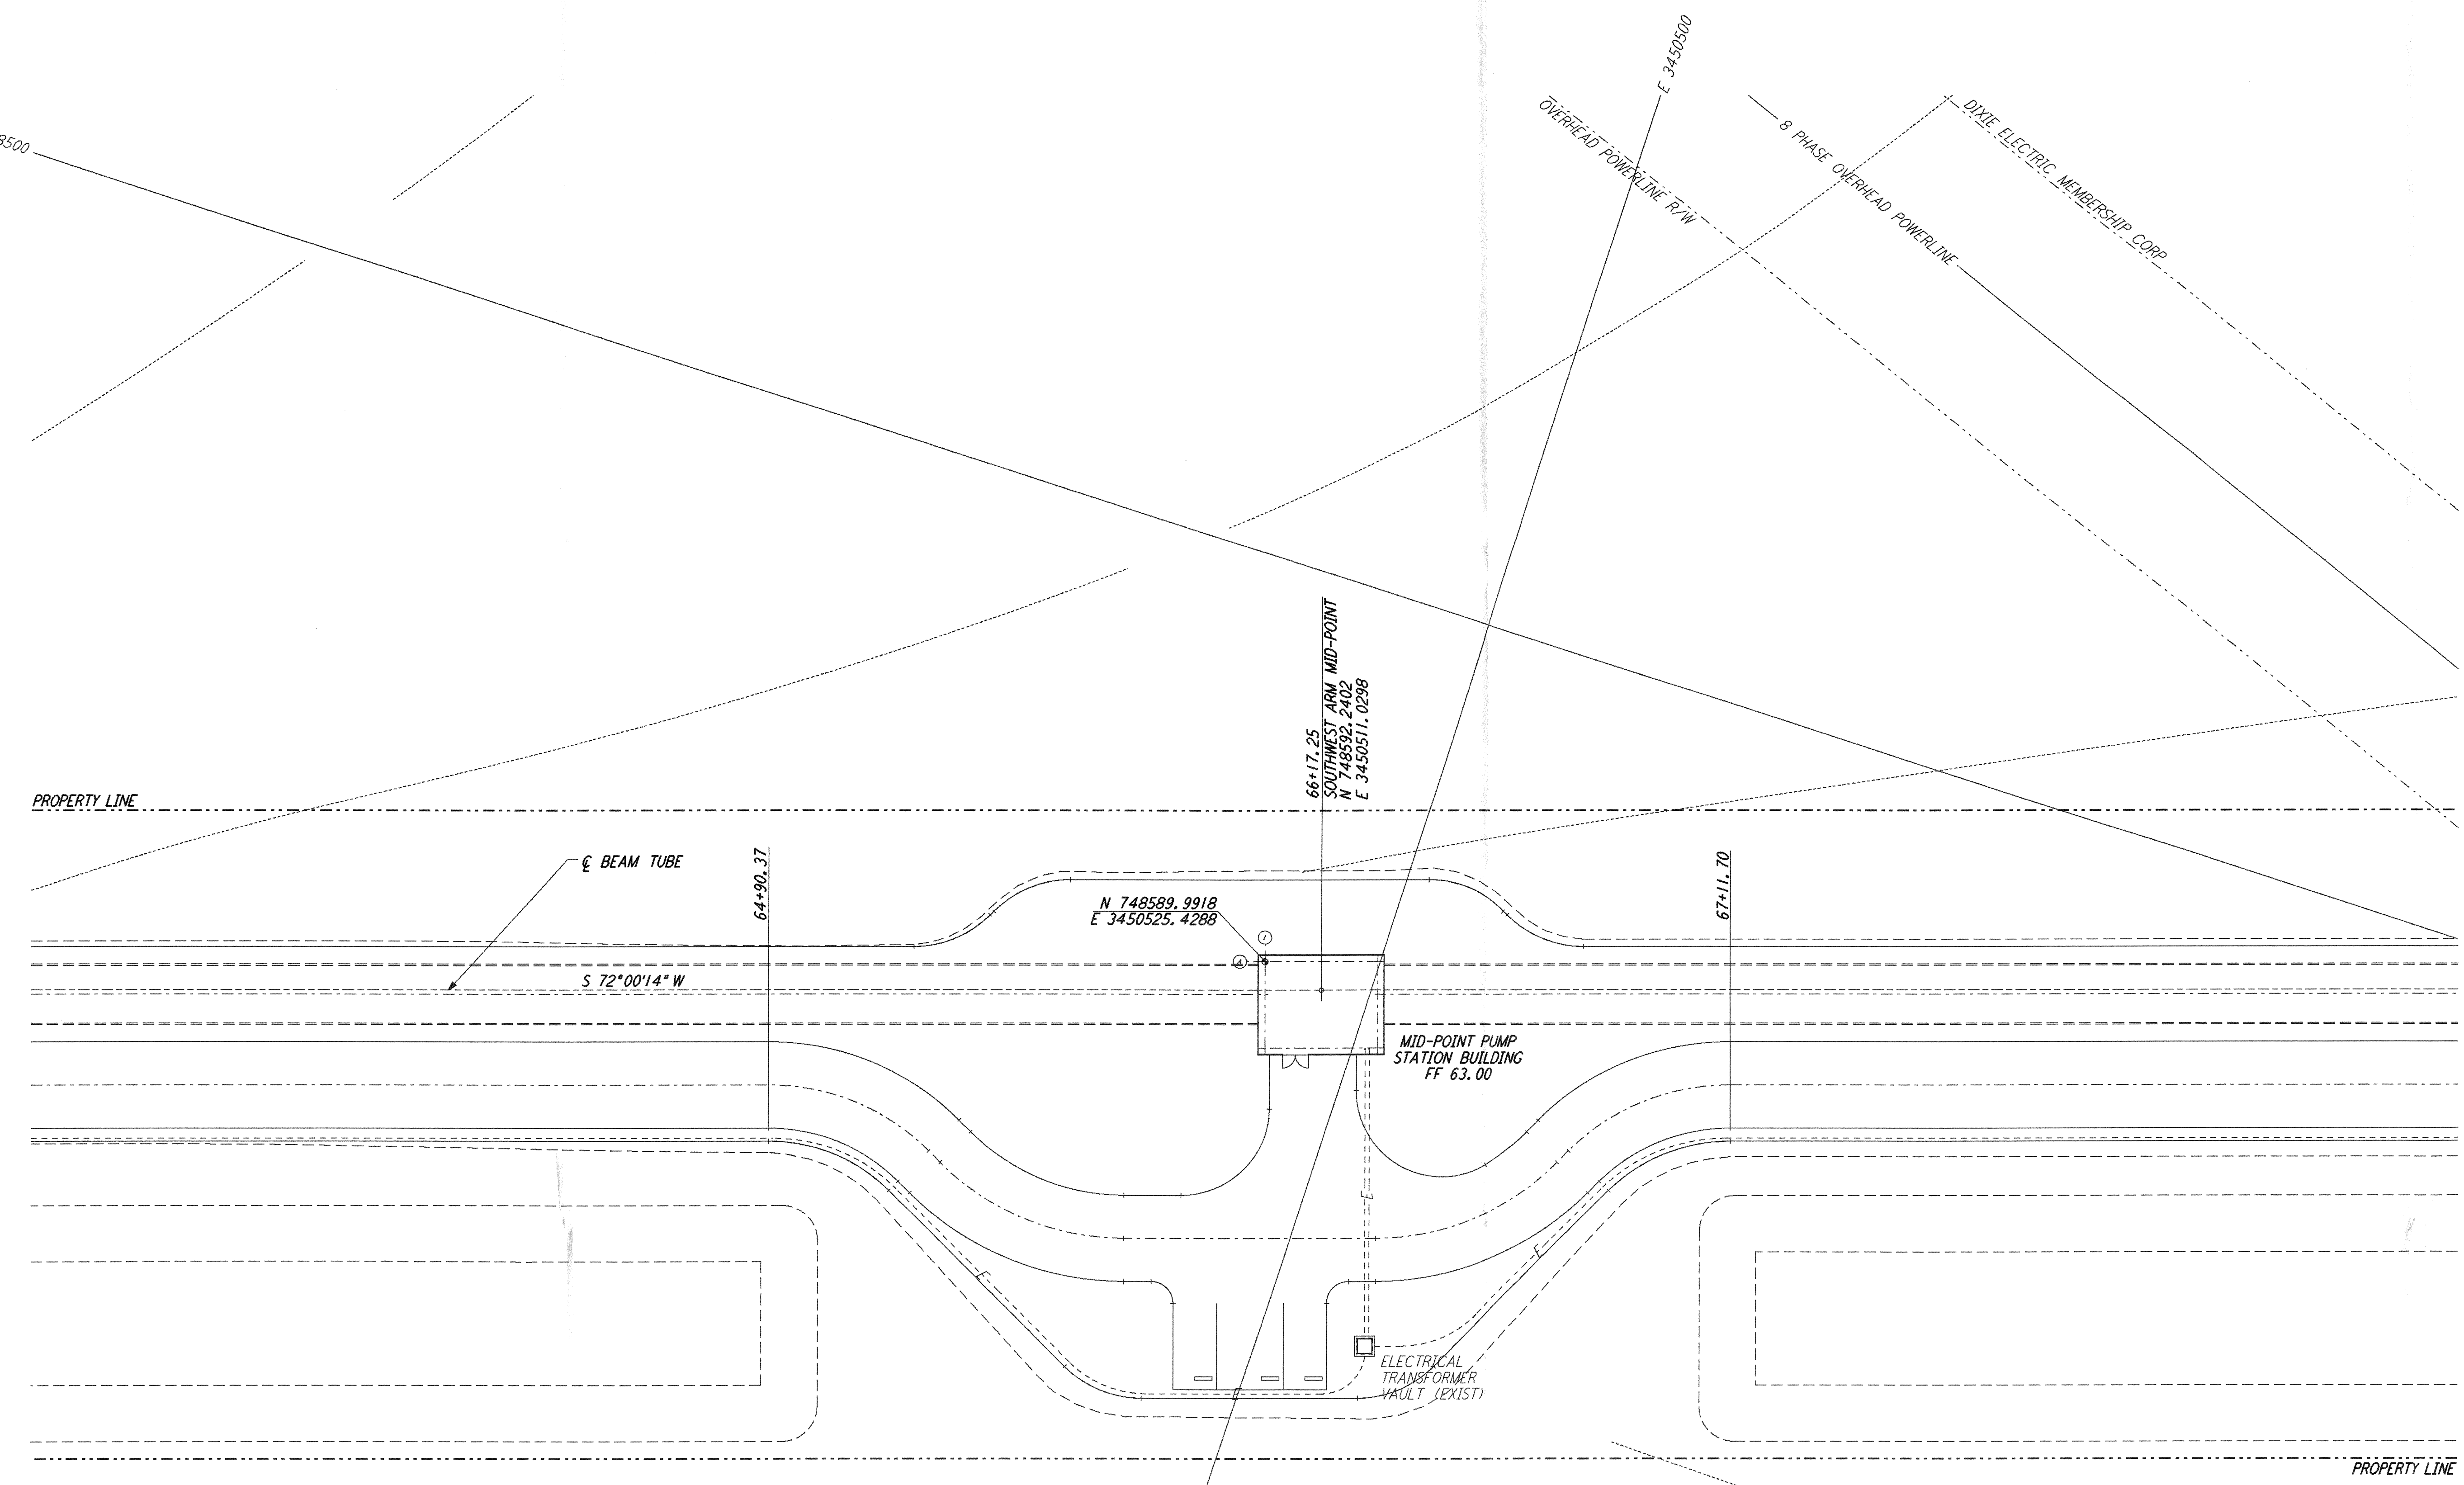
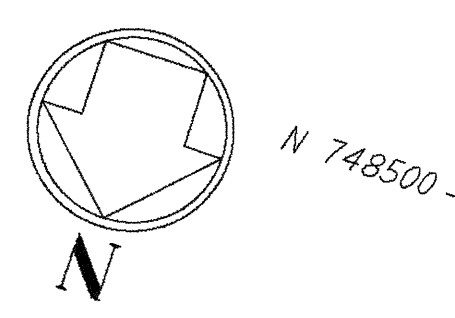


NOTES:
1. SEE SHEET LA-C-002 FOR GENERAL NOTES, LEGEND AND ABBREVIATIONS.

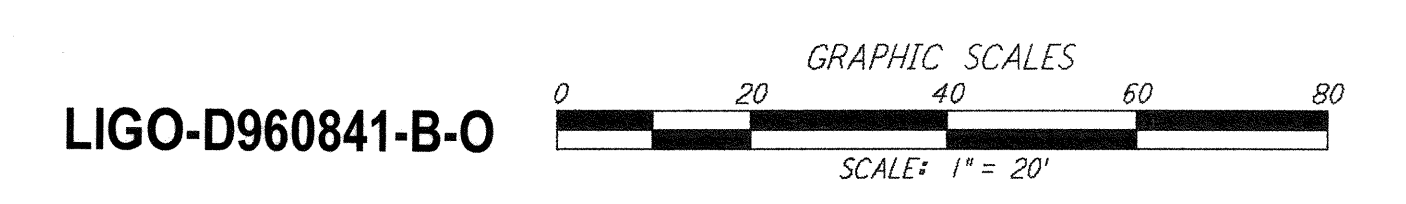

not be reproduced, copied, loaned, exhibited, or used in any other way, except by written consent from PARSONS to the borrower.

This document and the design it covers are the property of PARSONS. They are loaned only with the borrower's expressed written agreement that they will

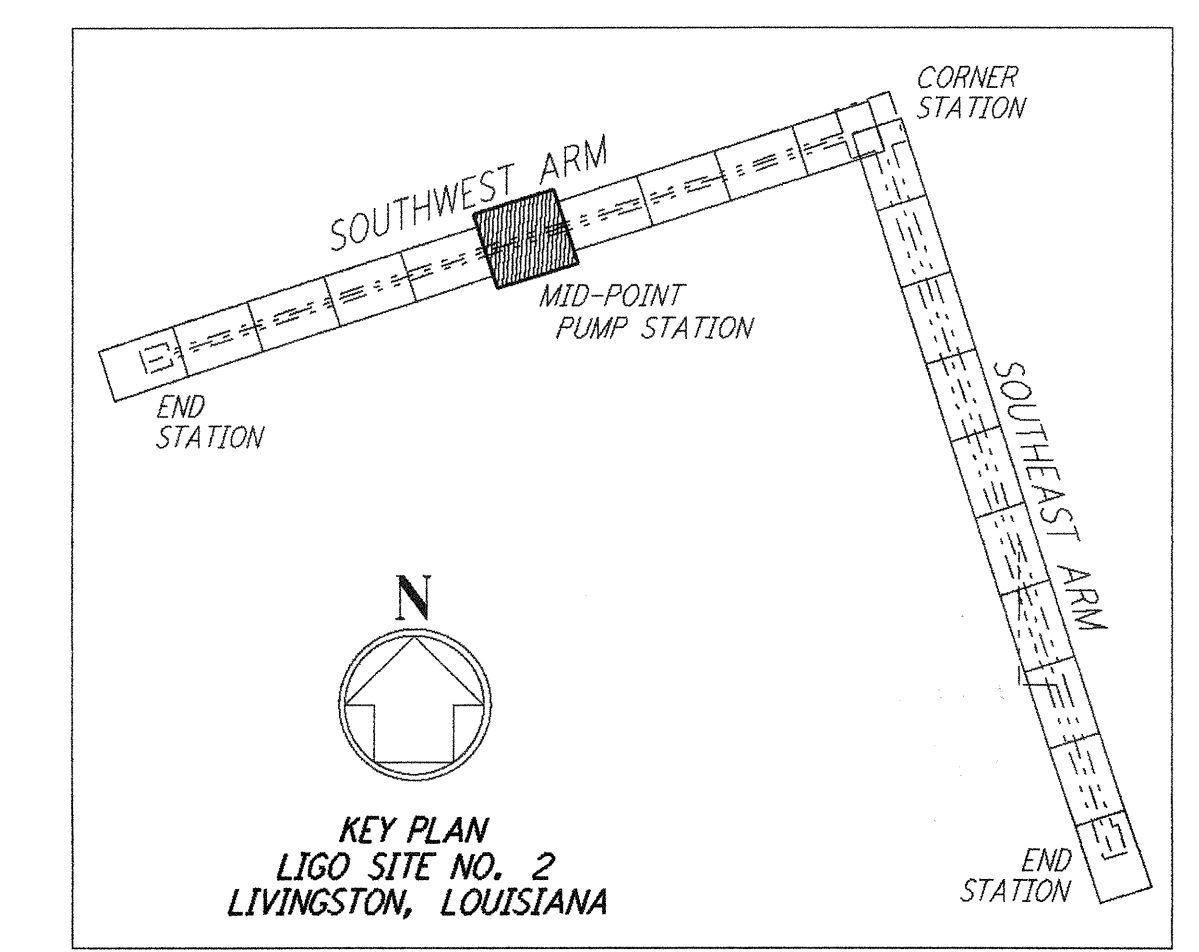

DRAWING NO.		DESCRIPTION		NO.		DATE		BY		CHKD		ENGR		PROJ		DESCRIPTION	
A		6/14/96		WRB		ML		JB		TDM						ISSUED FOR BID FINAL DESIGN REVIEW	
B		7/24/96		WRB		ML		JB		TDM							

DRAWN	WRB
CHECKED	
ENGINEER	
PROJ	



100 WEST WALNUT STREET
PASADENA, CALIFORNIA



CALIFORNIA INSTITUTE OF TECHNOLOGY
MASSACHUSETTS INSTITUTE OF TECHNOLOGY

LASER INTERFEROMETER
GRAVITATIONAL-WAVE OBSERVATORY
SITE NO. 2 - LIVINGSTON, LOUISIANA

TITLE	SCALE	CONTRACT NUMBER	PROJECT NUMBER
CIVIL SOUTHWEST ARM PUMP STATION UTILITY PLAN	1" = 20'	PP150969	8094
SHEET NUMBER		REVISIONS	
LA-C-023		[Symbol]	

1000 JUL 22 11:01:07 1996 53773002 J:\VPLU\S\WAVE\LOC023.DWG

\\lgo\site2\ce\loc023.dgz