



NOTES:
 1. FOR LEGEND, ABBREVIATIONS AND GENERAL NOTES SEE SHEETS
 LA-H-001 AND LA-H-002.

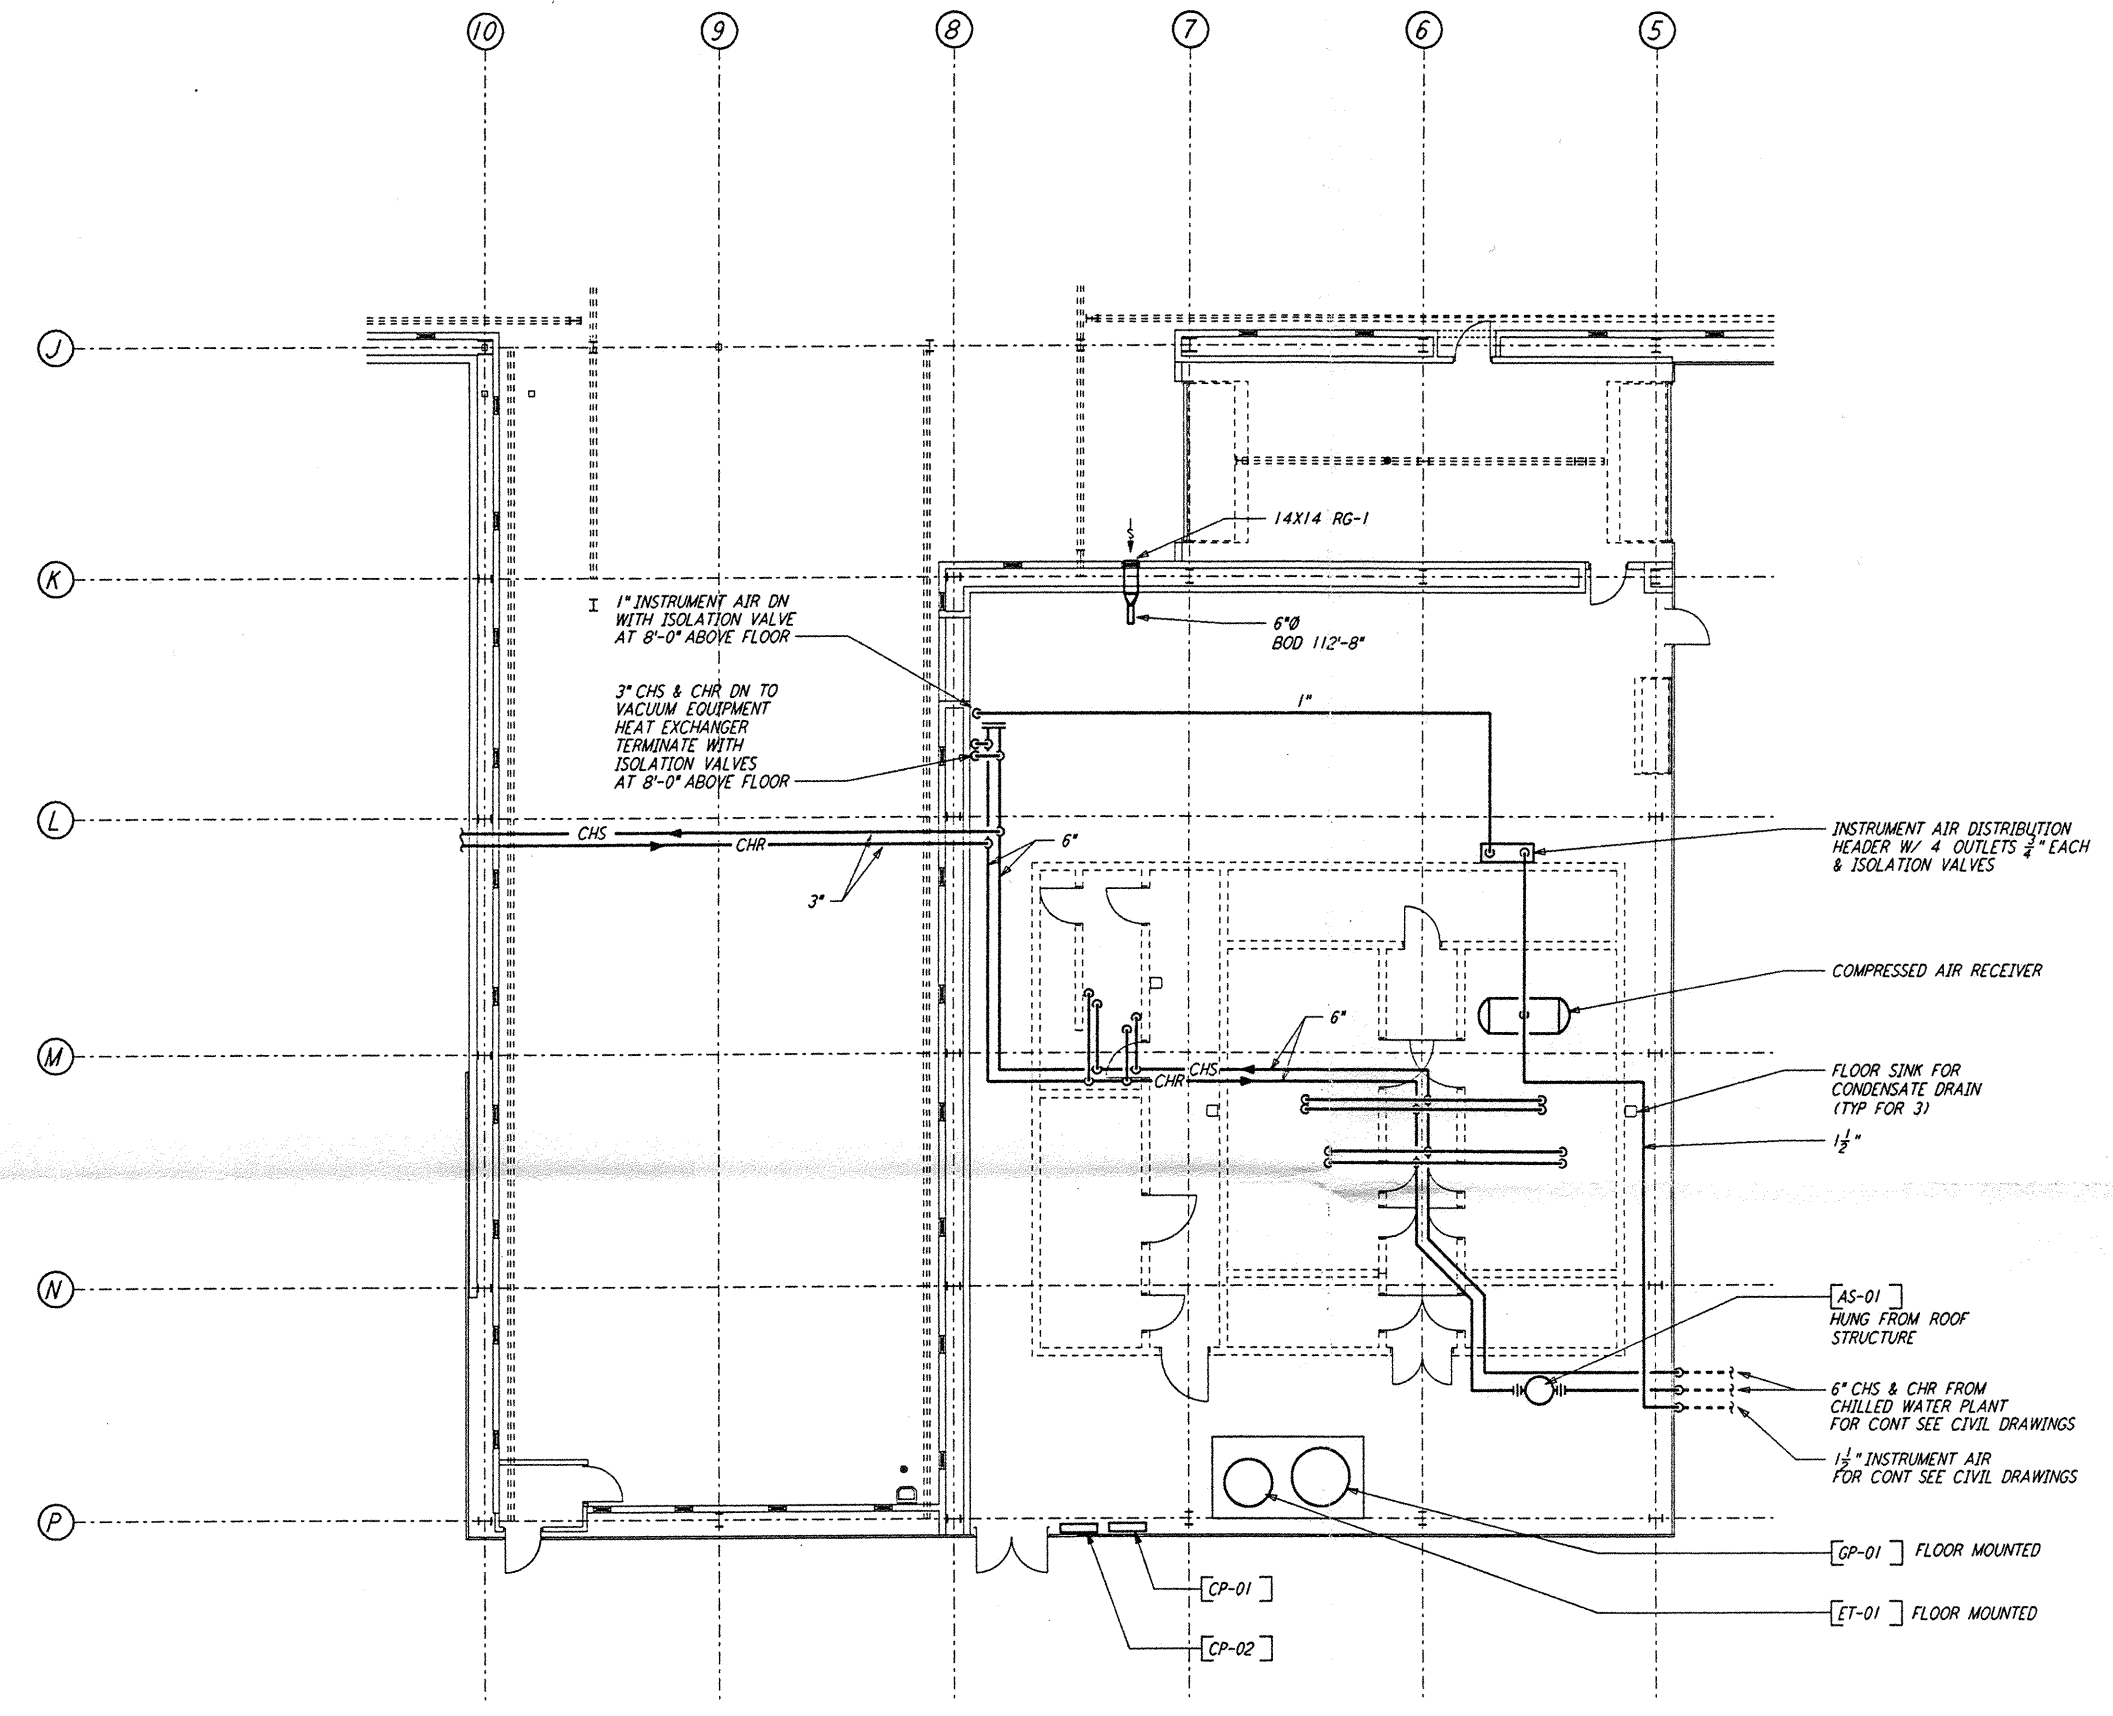

MECHANICAL ROOM PIPING PLAN
 1/8" = 1'-0"

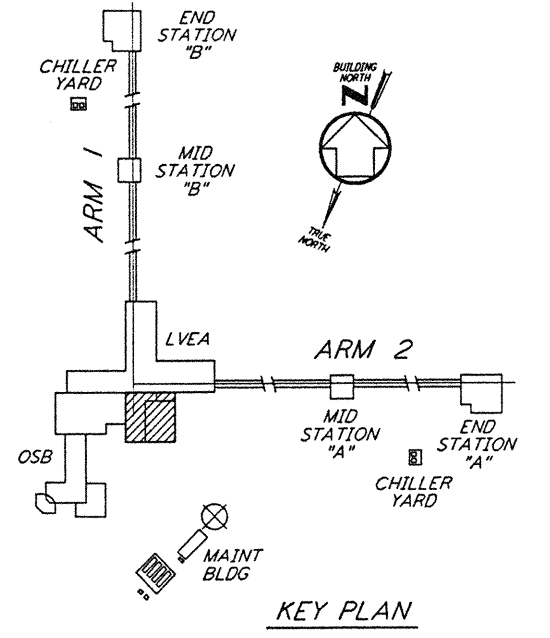

KEY PLAN
 1/8" = 1'-0"

not be reproduced, copied, loaned, exhibited, or used in any other way, except by written consent from PARSONS to the borrower.

This document and the design it covers are the property of PARSONS. They are loaned only with the borrower's expressed written agreement that they will

NO.	DATE	BY	CHKD	ENGR	PROJ	DESCRIPTION

ISSUED FOR CONSTRUCTION	CLP	11-15-96
CHECKED	AA	10-25-96
ENGINEER	AA	10-23-96
PROJ		



PARSONS
 100 WEST WALNUT STREET
 PASADENA, CALIFORNIA

LIGO
 CALIFORNIA INSTITUTE OF TECHNOLOGY
 MASSACHUSETTS INSTITUTE OF TECHNOLOGY

LASER INTERFEROMETER GRAVITATIONAL-WAVE OBSERVATORY SITE NO. 2 - LIVINGSTON, LOUISIANA		
TITLE	SCALE	CONTRACT NUMBER
HVAC CORNER STATION LVEA & OSB MECHANICAL ROOM PIPING PLAN	AS NOTED	PP150969
PROJECT NUMBER	8094	
SHEET NUMBER		REVISIONS
LA-H-117		