


This document and the design it covers are the property of PARSONS. They are loaned only with the borrower's expressed written agreement that they will not be reproduced, copied, loaned, exhibited, or used in any other way, except by written consent from PARSONS to the borrower.

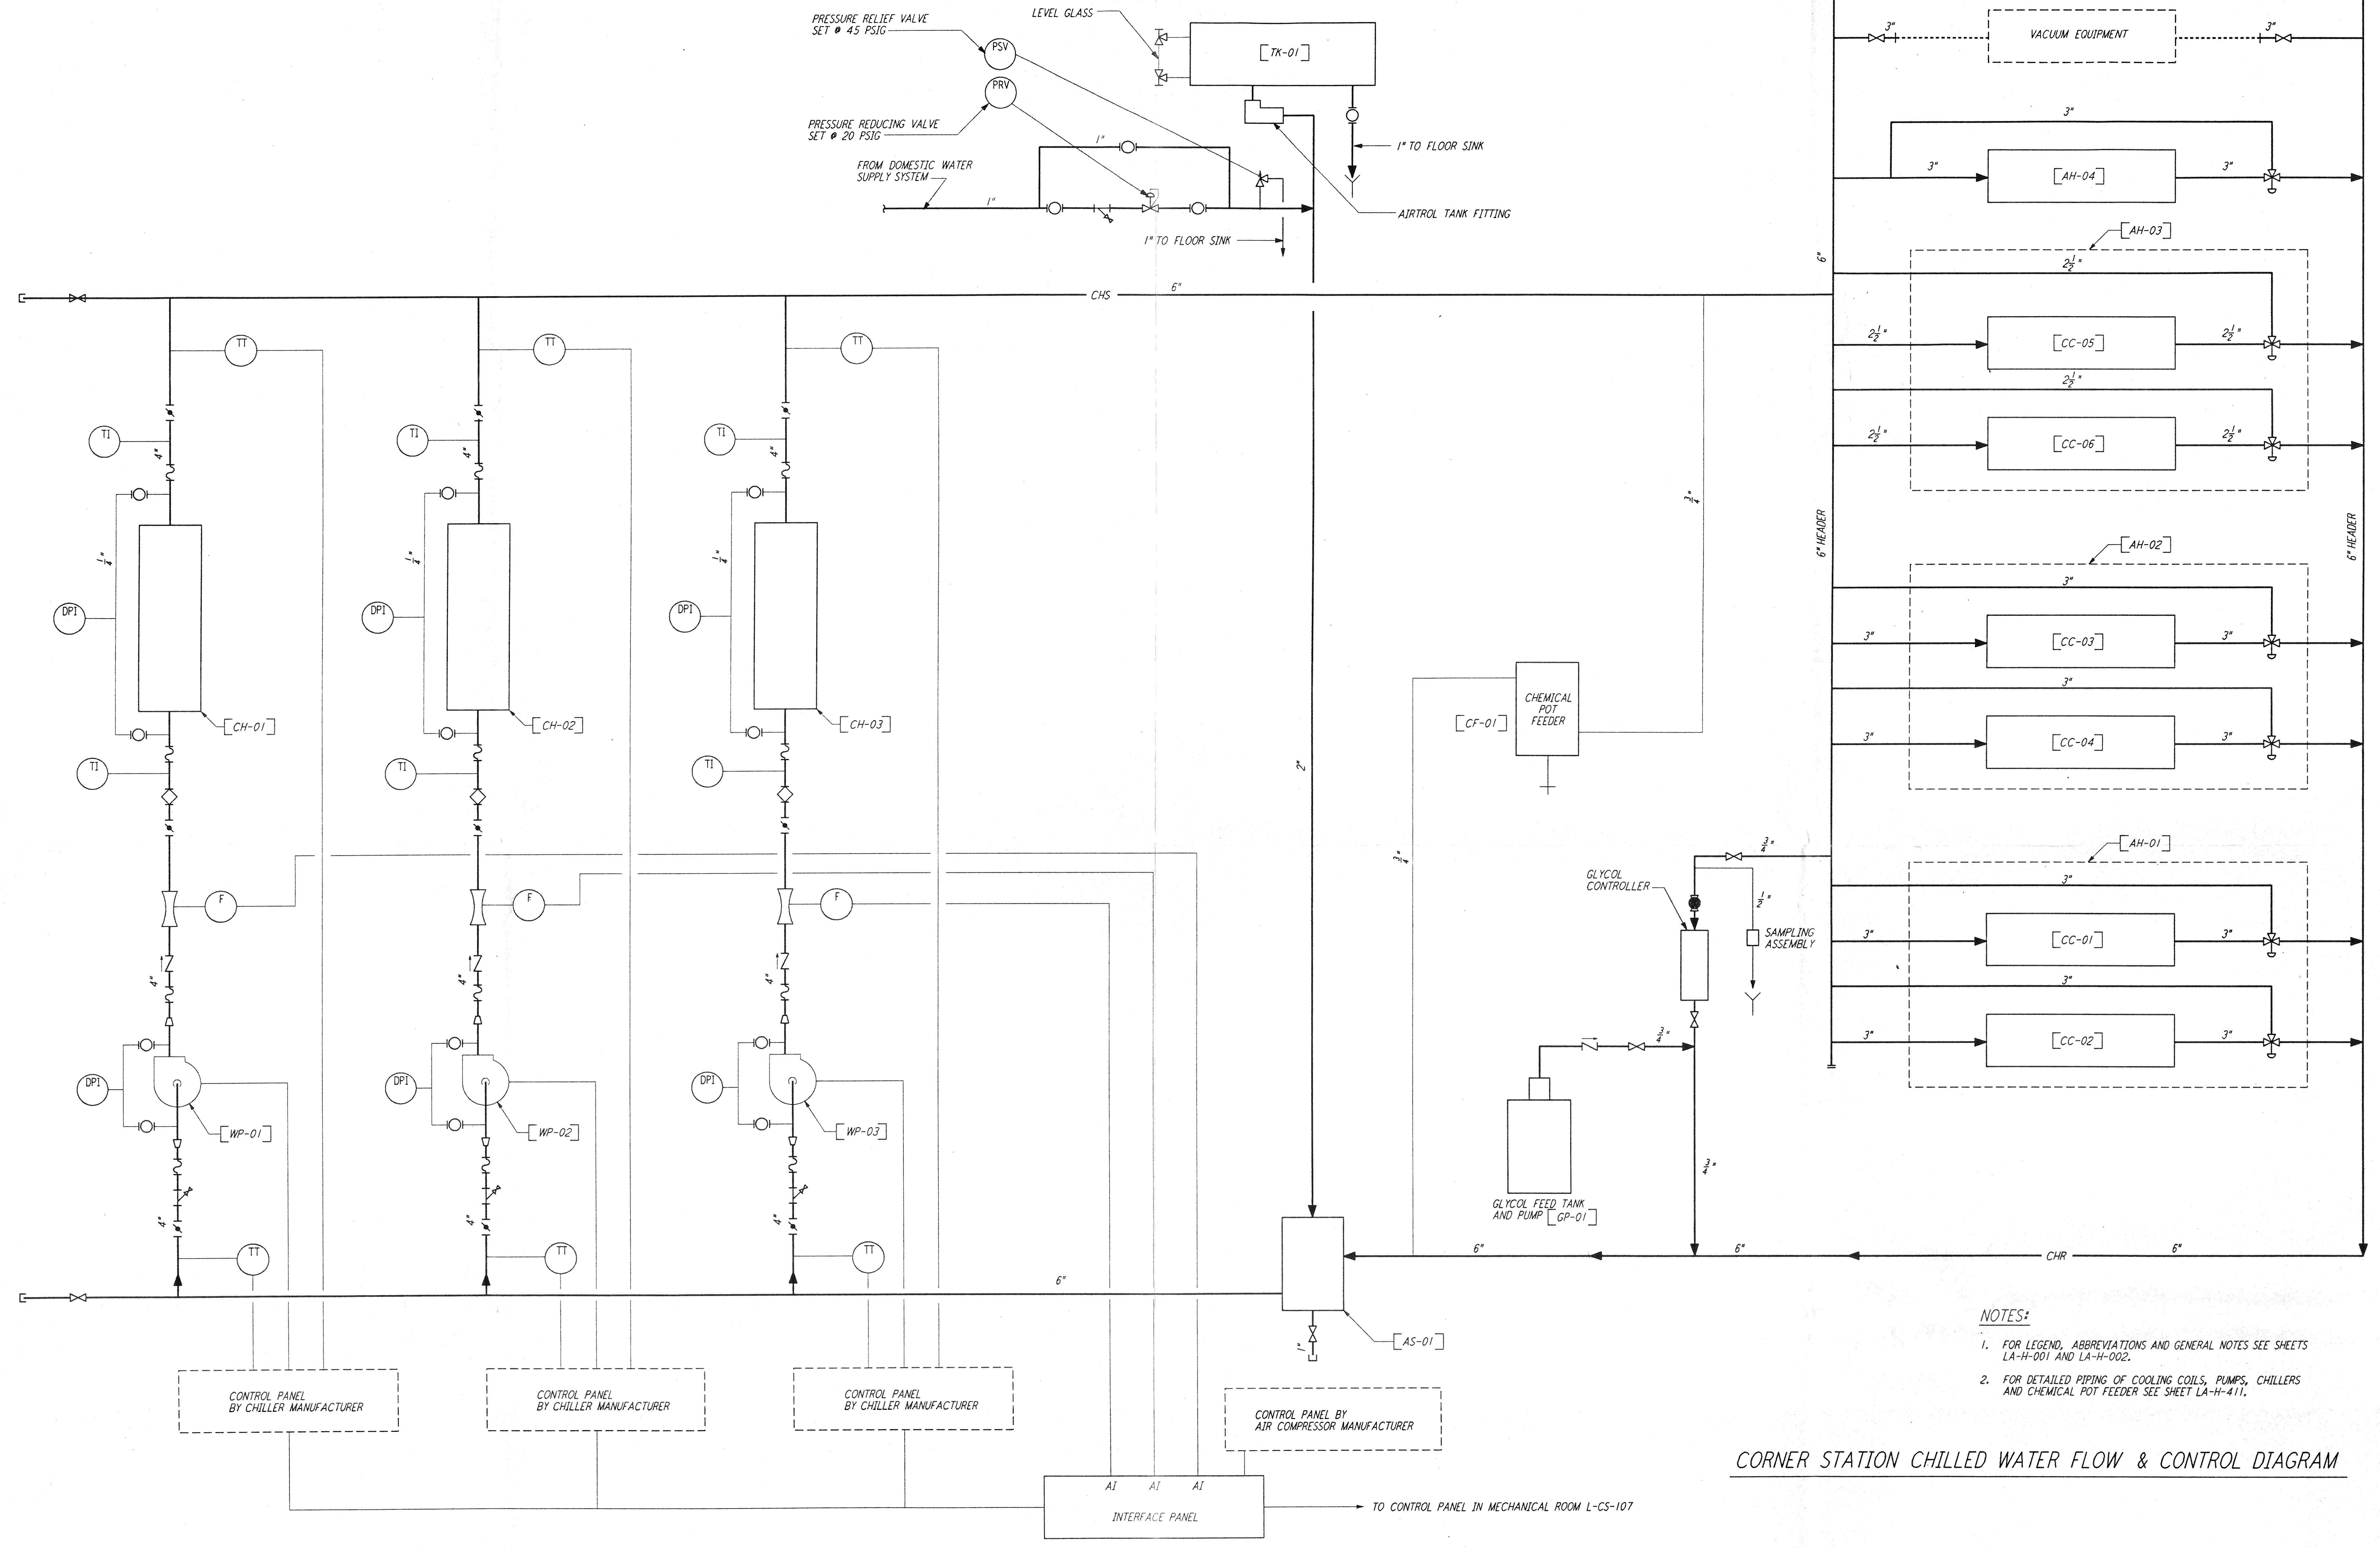


- NOTES:**
- FOR LEGEND, ABBREVIATIONS AND GENERAL NOTES SEE SHEETS LA-H-001 AND LA-H-002.
 - FOR DETAILED PIPING OF COOLING COILS, PUMPS, CHILLERS AND CHEMICAL POT FEEDER SEE SHEET LA-H-411.

CORNER STATION CHILLED WATER FLOW & CONTROL DIAGRAM

NO.	DATE	BY	CHKD	ENGR	PROJ	DESCRIPTION

ISSUED FOR CONSTRUCTION
 DRAWN CLP 11-15-96
 CHECKED MA 10-25-96
 ENGINEER AA 10-23-96
 PROJ EDA 11/15/96

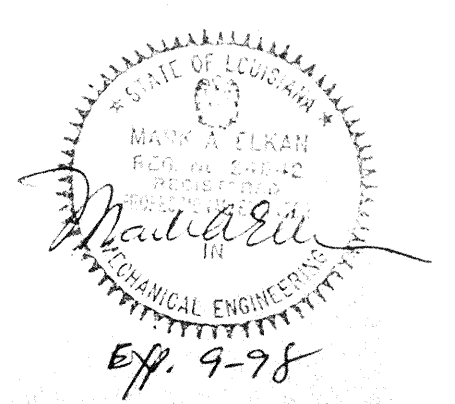

LASER INTERFEROMETER GRAVITATIONAL-WAVE OBSERVATORY SITE NO. 2 - LIVINGSTON, LOUISIANA		
TITLE	SCALE	CONTRACT NUMBER
HVAC CORNER STATION CHILLED WATER FLOW DIAGRAM	NONE	PP150969
SHEET NUMBER	PROJECT NUMBER	8094
LA-H-121	REVISIONS	