


This document and the design it covers are the property of PARSONS. They are loaned only with the borrower's expressed written agreement that they will not be reproduced, copied, loaned, exhibited, or used in any other way, except by written consent from PARSONS to the borrower.

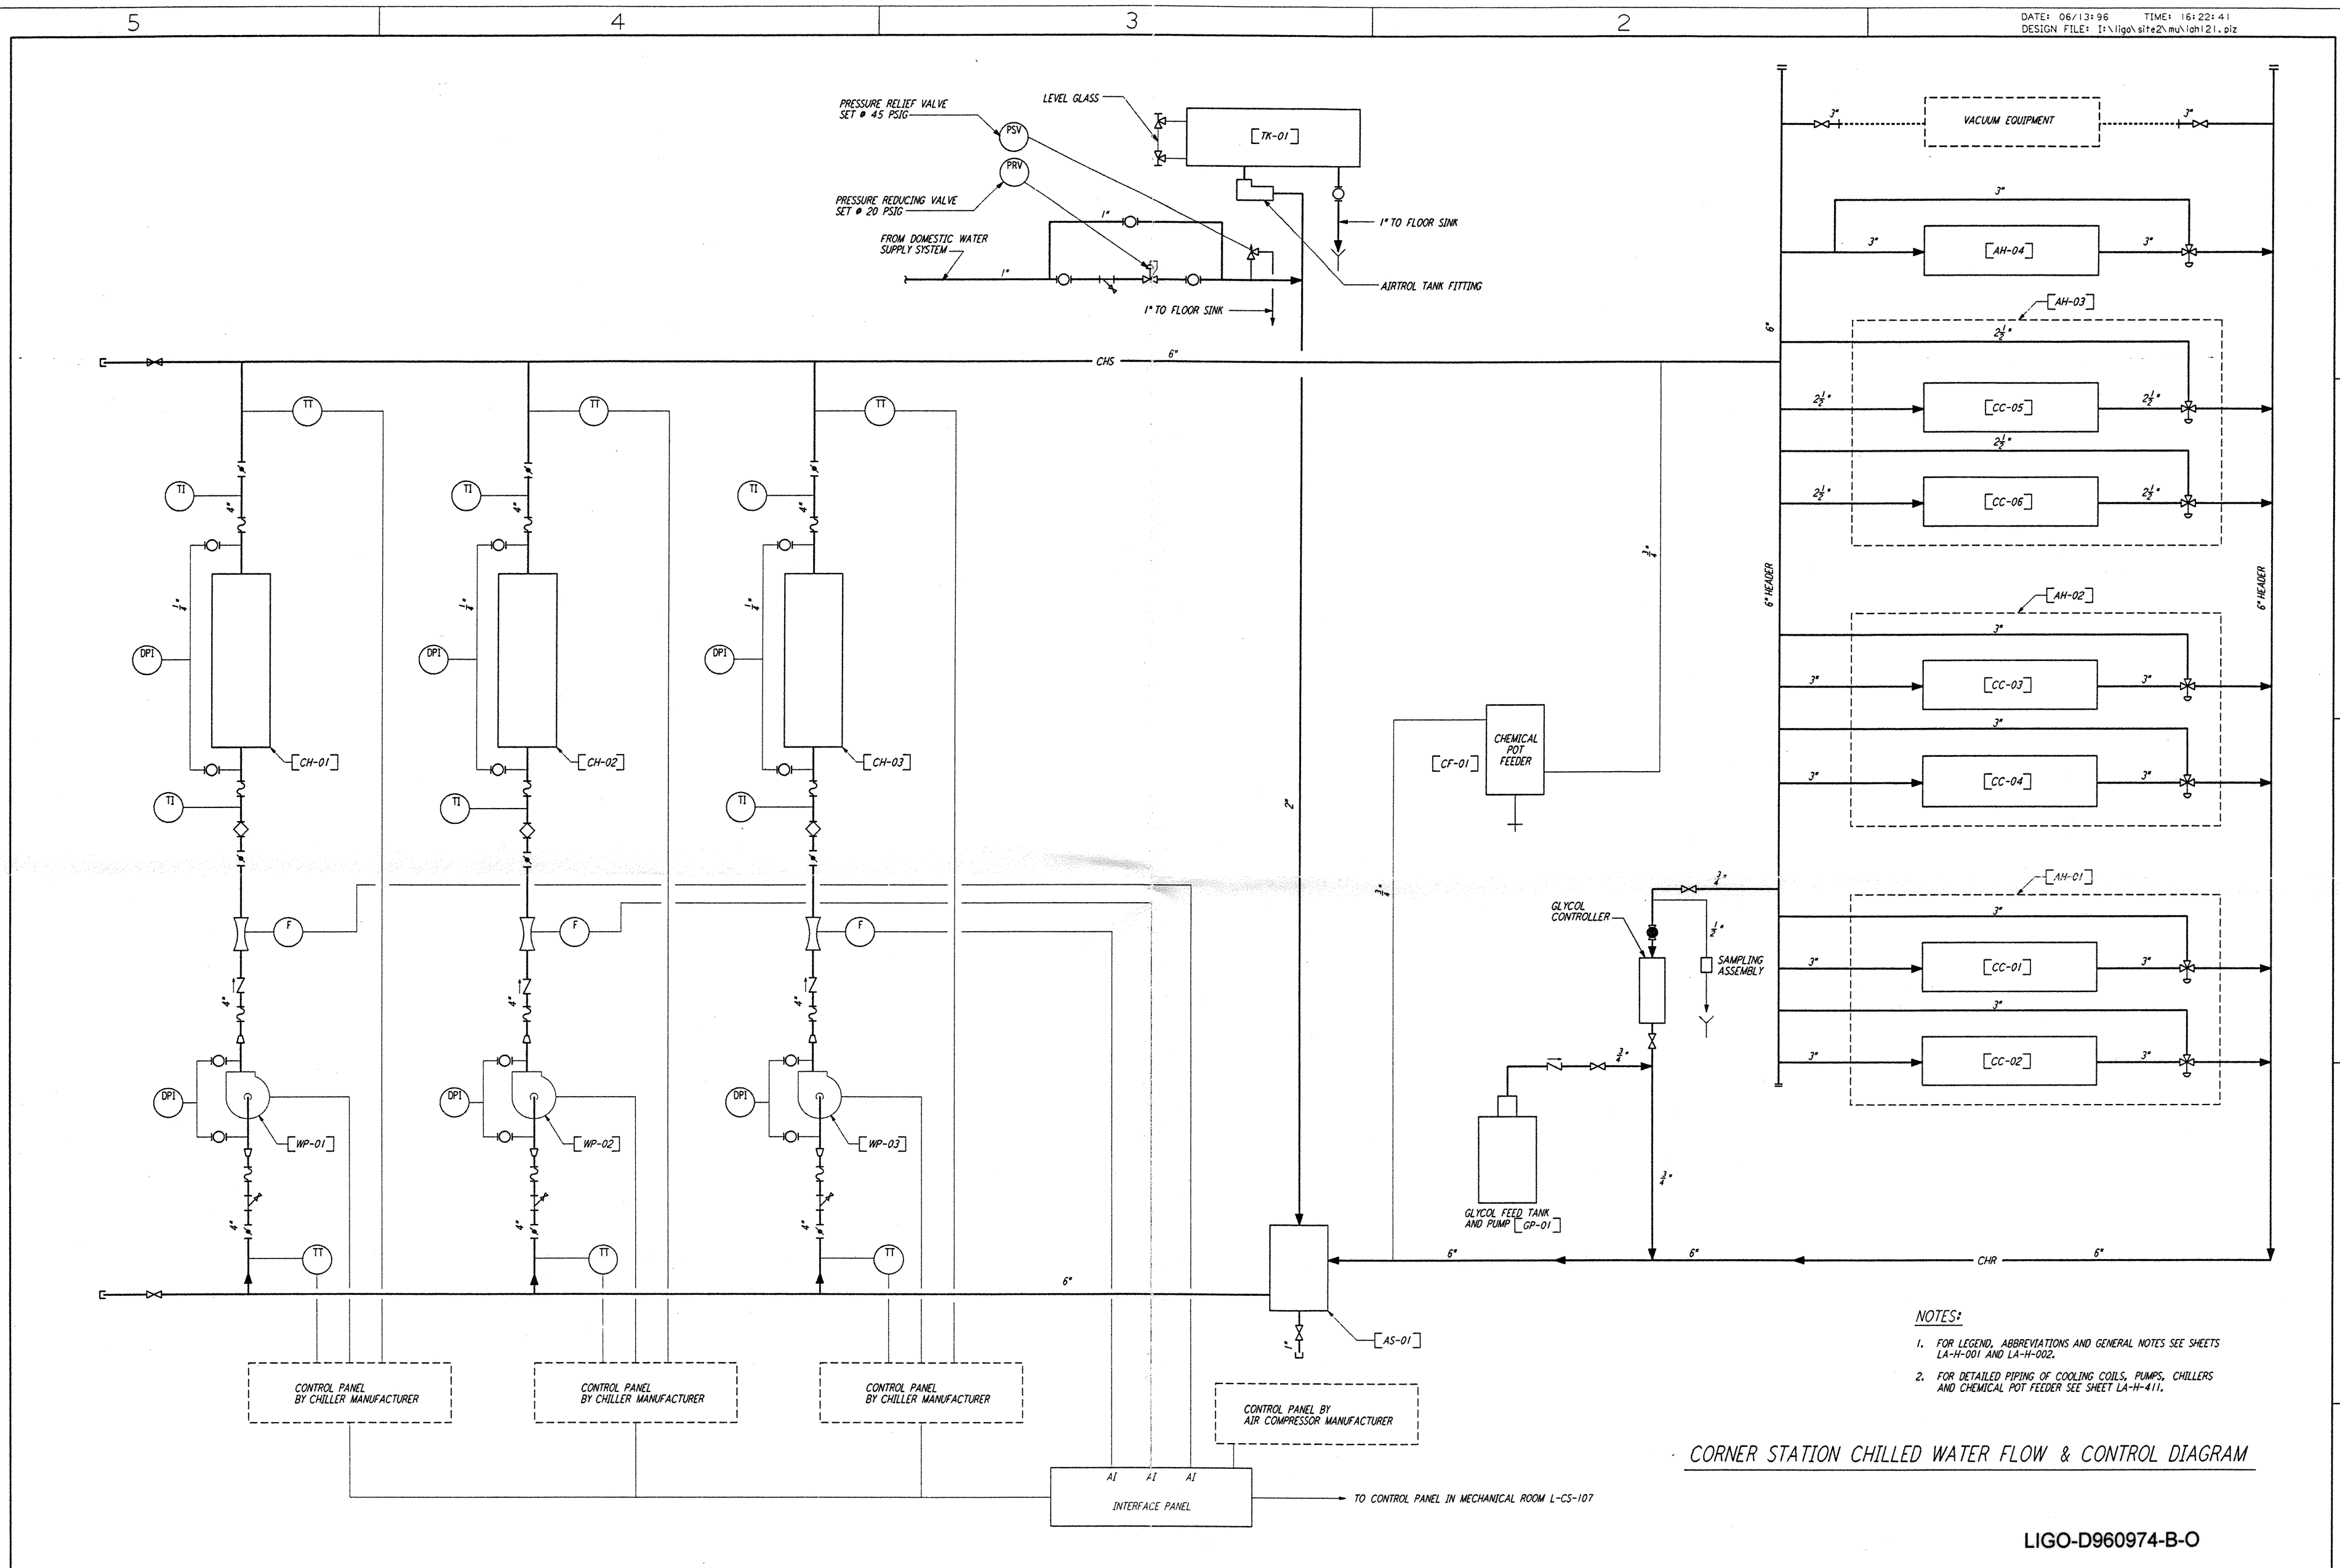

- NOTES:**
- FOR LEGEND, ABBREVIATIONS AND GENERAL NOTES SEE SHEETS LA-H-001 AND LA-H-002.
 - FOR DETAILED PIPING OF COOLING COILS, PUMPS, CHILLERS AND CHEMICAL POT FEEDER SEE SHEET LA-H-411.

CORNER STATION CHILLED WATER FLOW & CONTROL DIAGRAM

LIGO-D960974-B-0

NO.	DATE	BY	CHKD	ENGR	PROJ	DESCRIPTION
B	6-14-96	CLP	ME	AA	TDM	FINAL DESIGN REVIEW
A	10-31-95	CLP	ME	AA	TDM	PRELIMINARY DESIGN REVIEW

DRAWN	CLP
CHECKED	
ENGINEER	
PROJ	

PARSONS
 100 WEST WALNUT STREET
 PASADENA, CALIFORNIA

LIGO
 CALIFORNIA INSTITUTE OF TECHNOLOGY
 MASSACHUSETTS INSTITUTE OF TECHNOLOGY

LASER INTERFEROMETER
 GRAVITATIONAL-WAVE OBSERVATORY
 SITE NO. 2 - LIVINGSTON, LOUISIANA

TITLE	SCALE	CONTRACT NUMBER	PROJECT NUMBER
HVAC CORNER STATION CHILLED WATER FLOW DIAGRAM	NONE	PPI50969	8094
SHEET NUMBER			REVISIONS
LA-H-121			

THE DATE IS 10/26/95 17:06 517.0000 J:\PLANS\SUBS\11\0362\WV\121.DWG

THE DATE IS 10/26/95 17:06 517.0000 J:\PLANS\SUBS\11\0362\WV\121.DWG