




- NOTES:**
- FOR LEGEND, ABBREVIATIONS AND GENERAL NOTES SEE SHEET LA-H-001 AND LA-H-002.
  - SEE INPUT/OUTPUT SUMMARY SHEETS, SHEETS LA-H-141 AND LA-H-142 FOR ALARMS AND EQUIPMENT CONTROL.

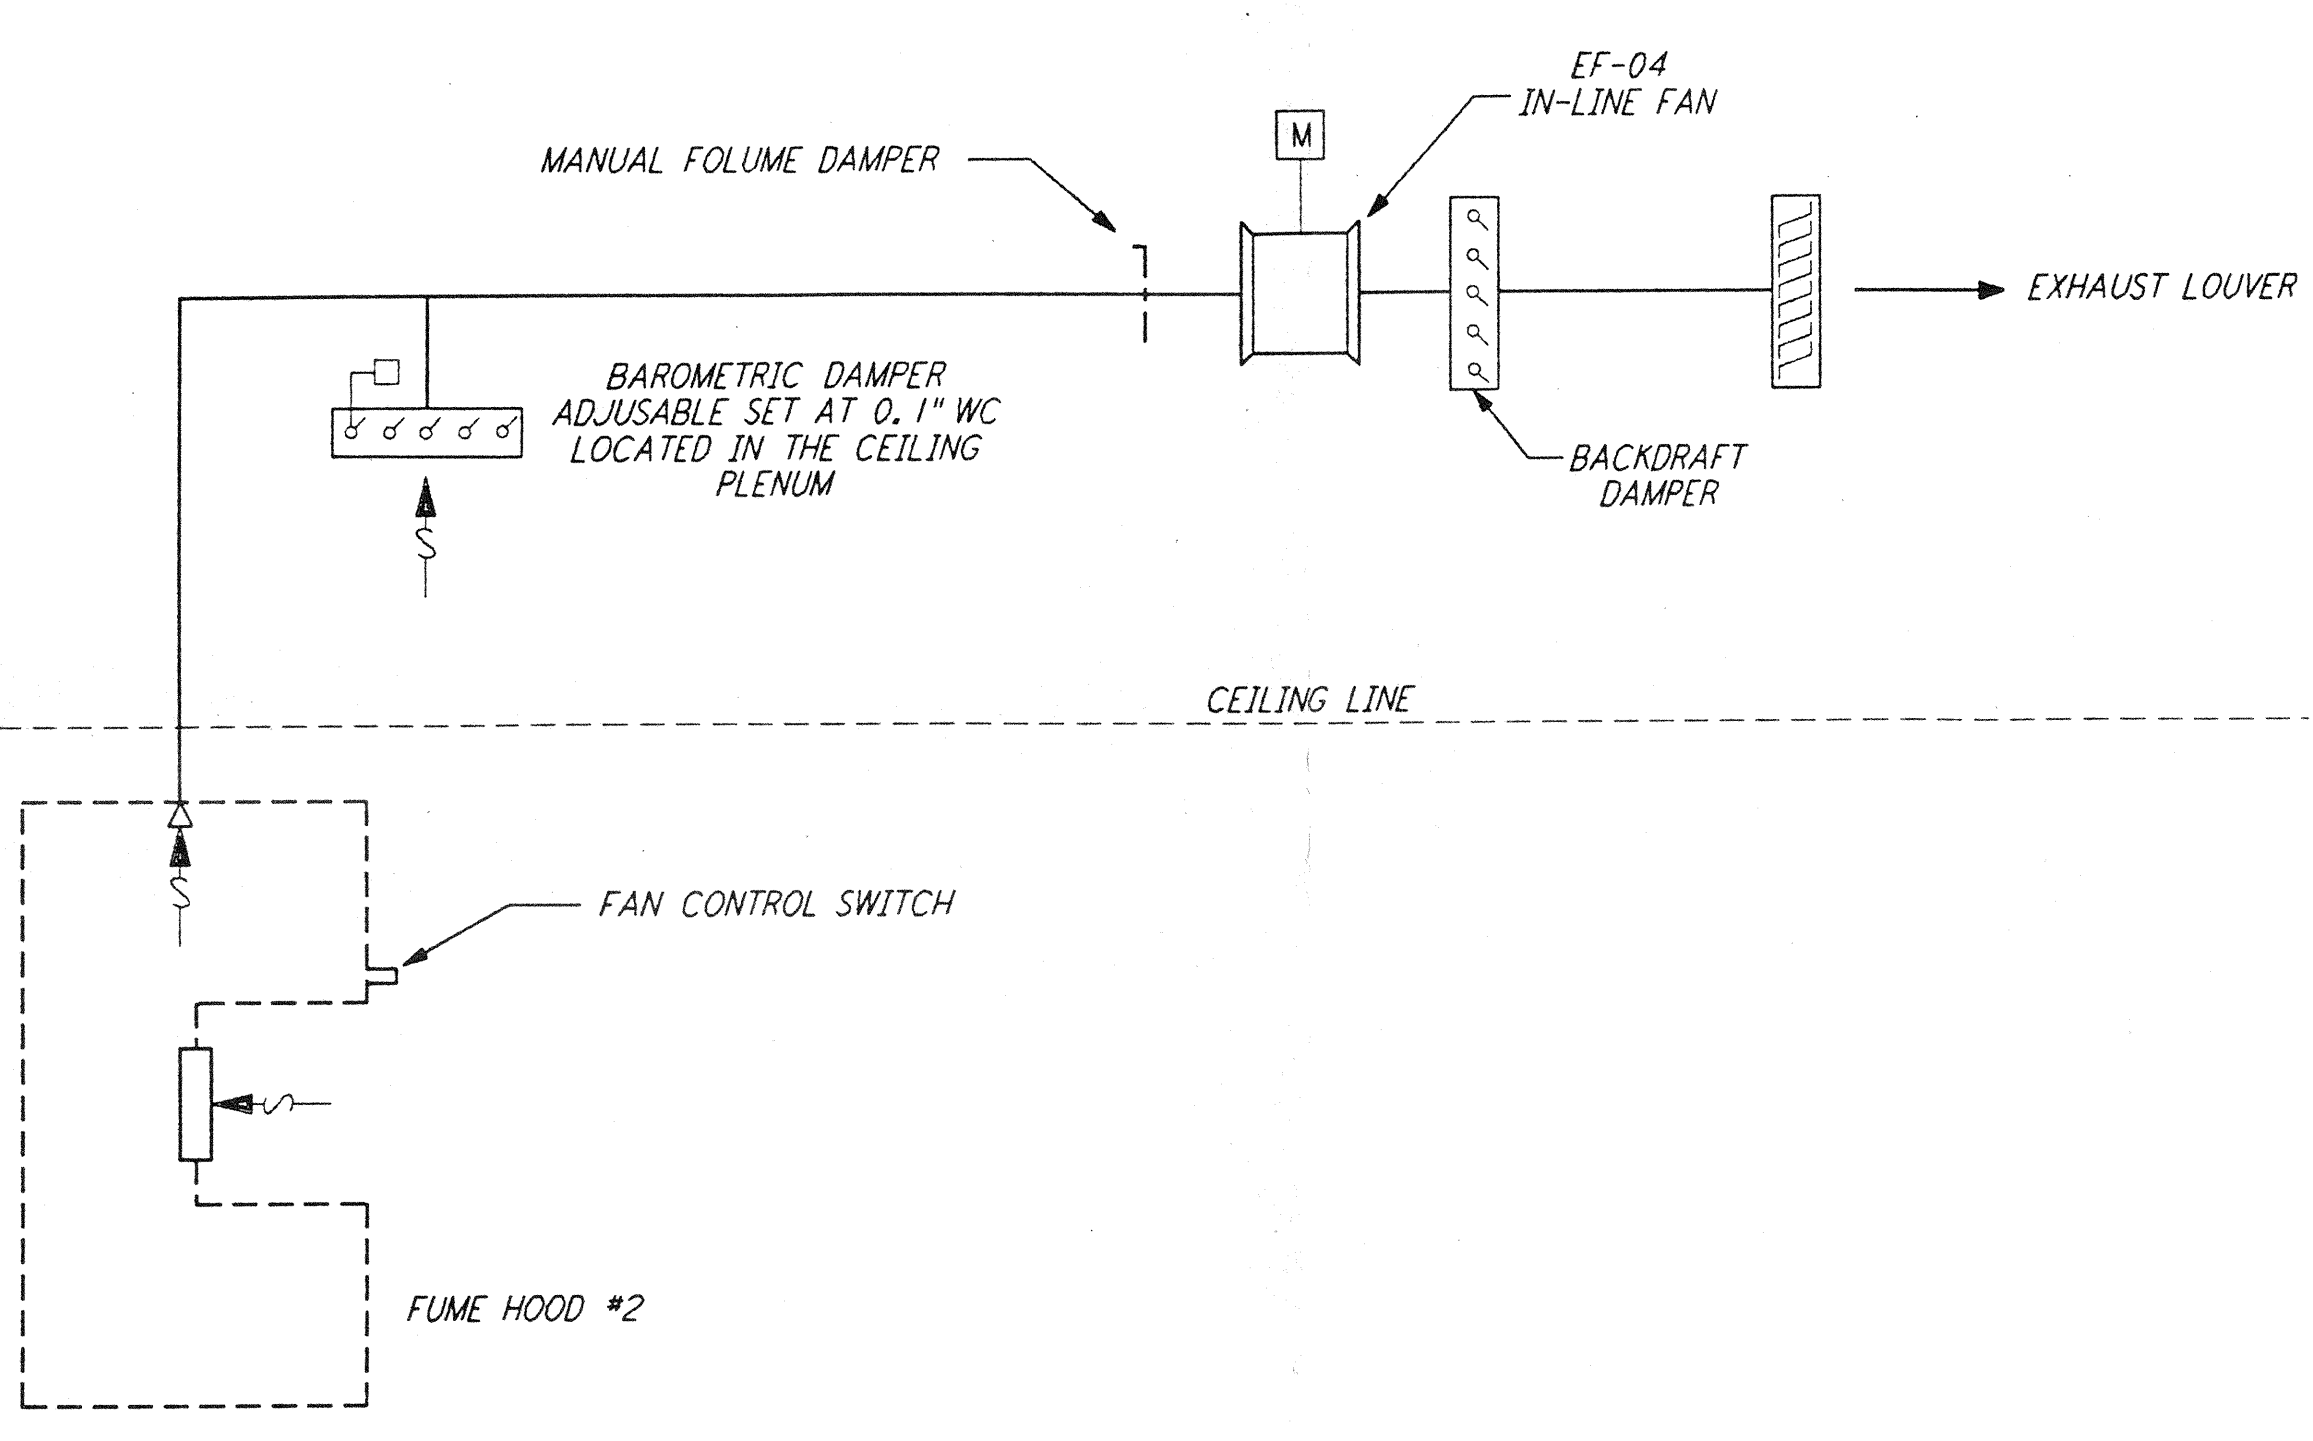

VACUUM PREPARATION FUME HOOD CONTROL DIAGRAM

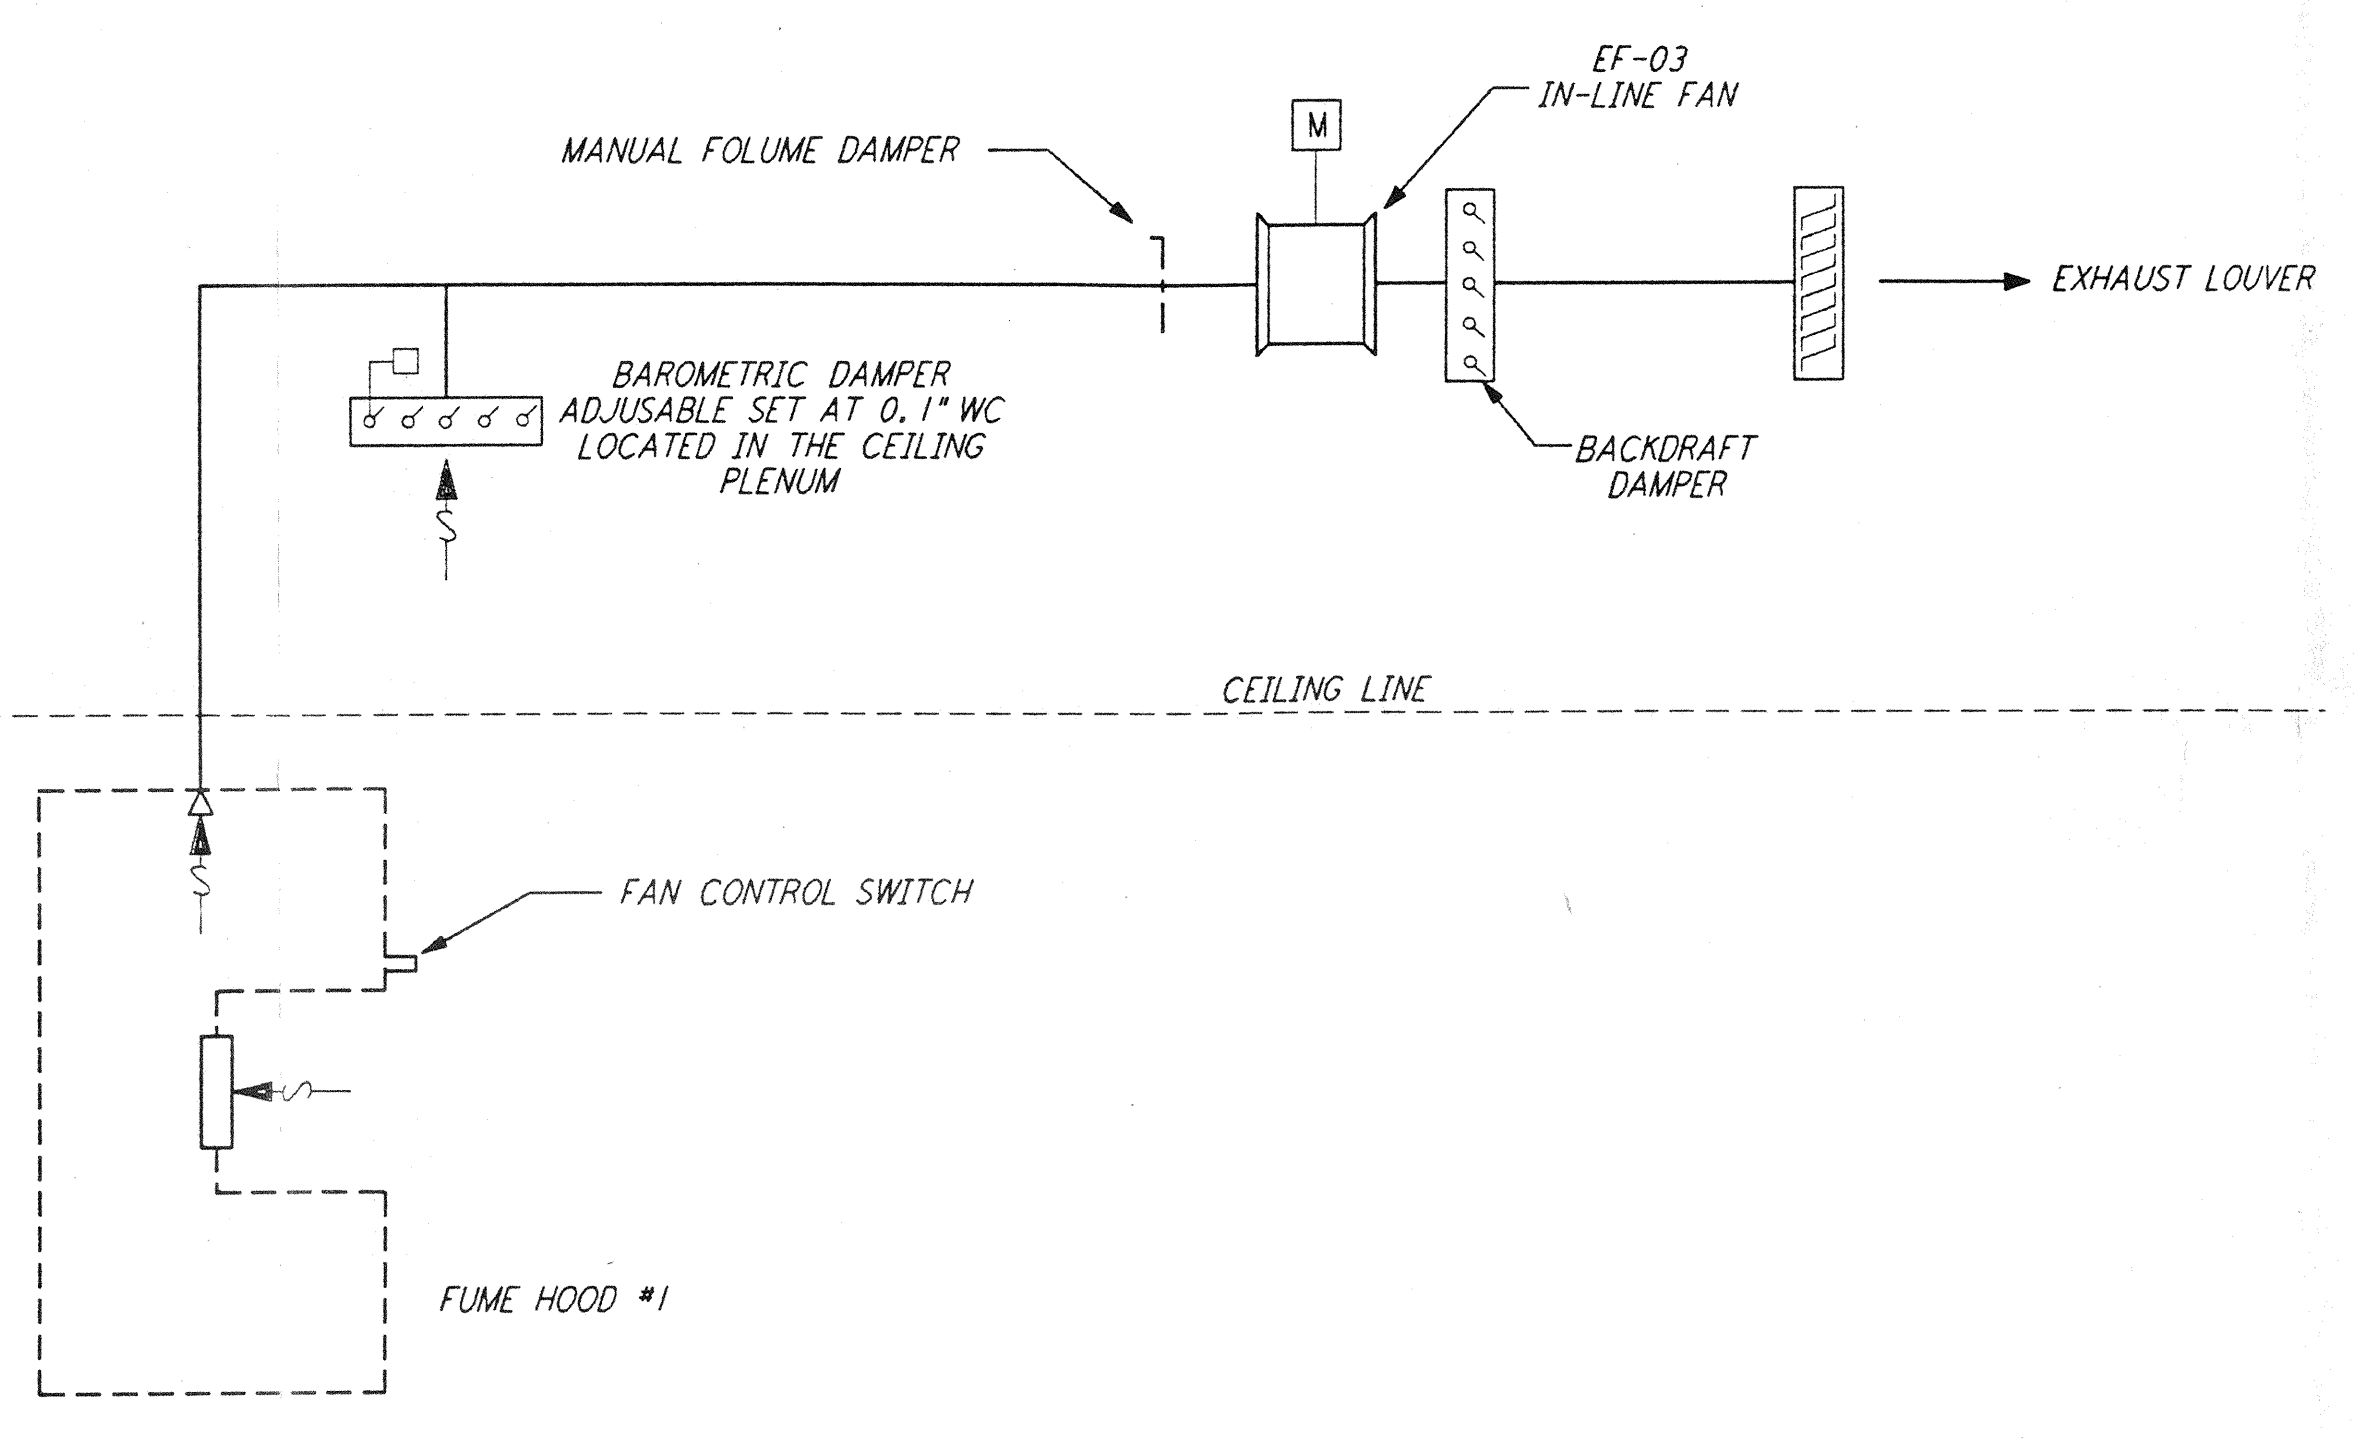

OPTICS LAB FUME HOOD CONTROL DIAGRAM

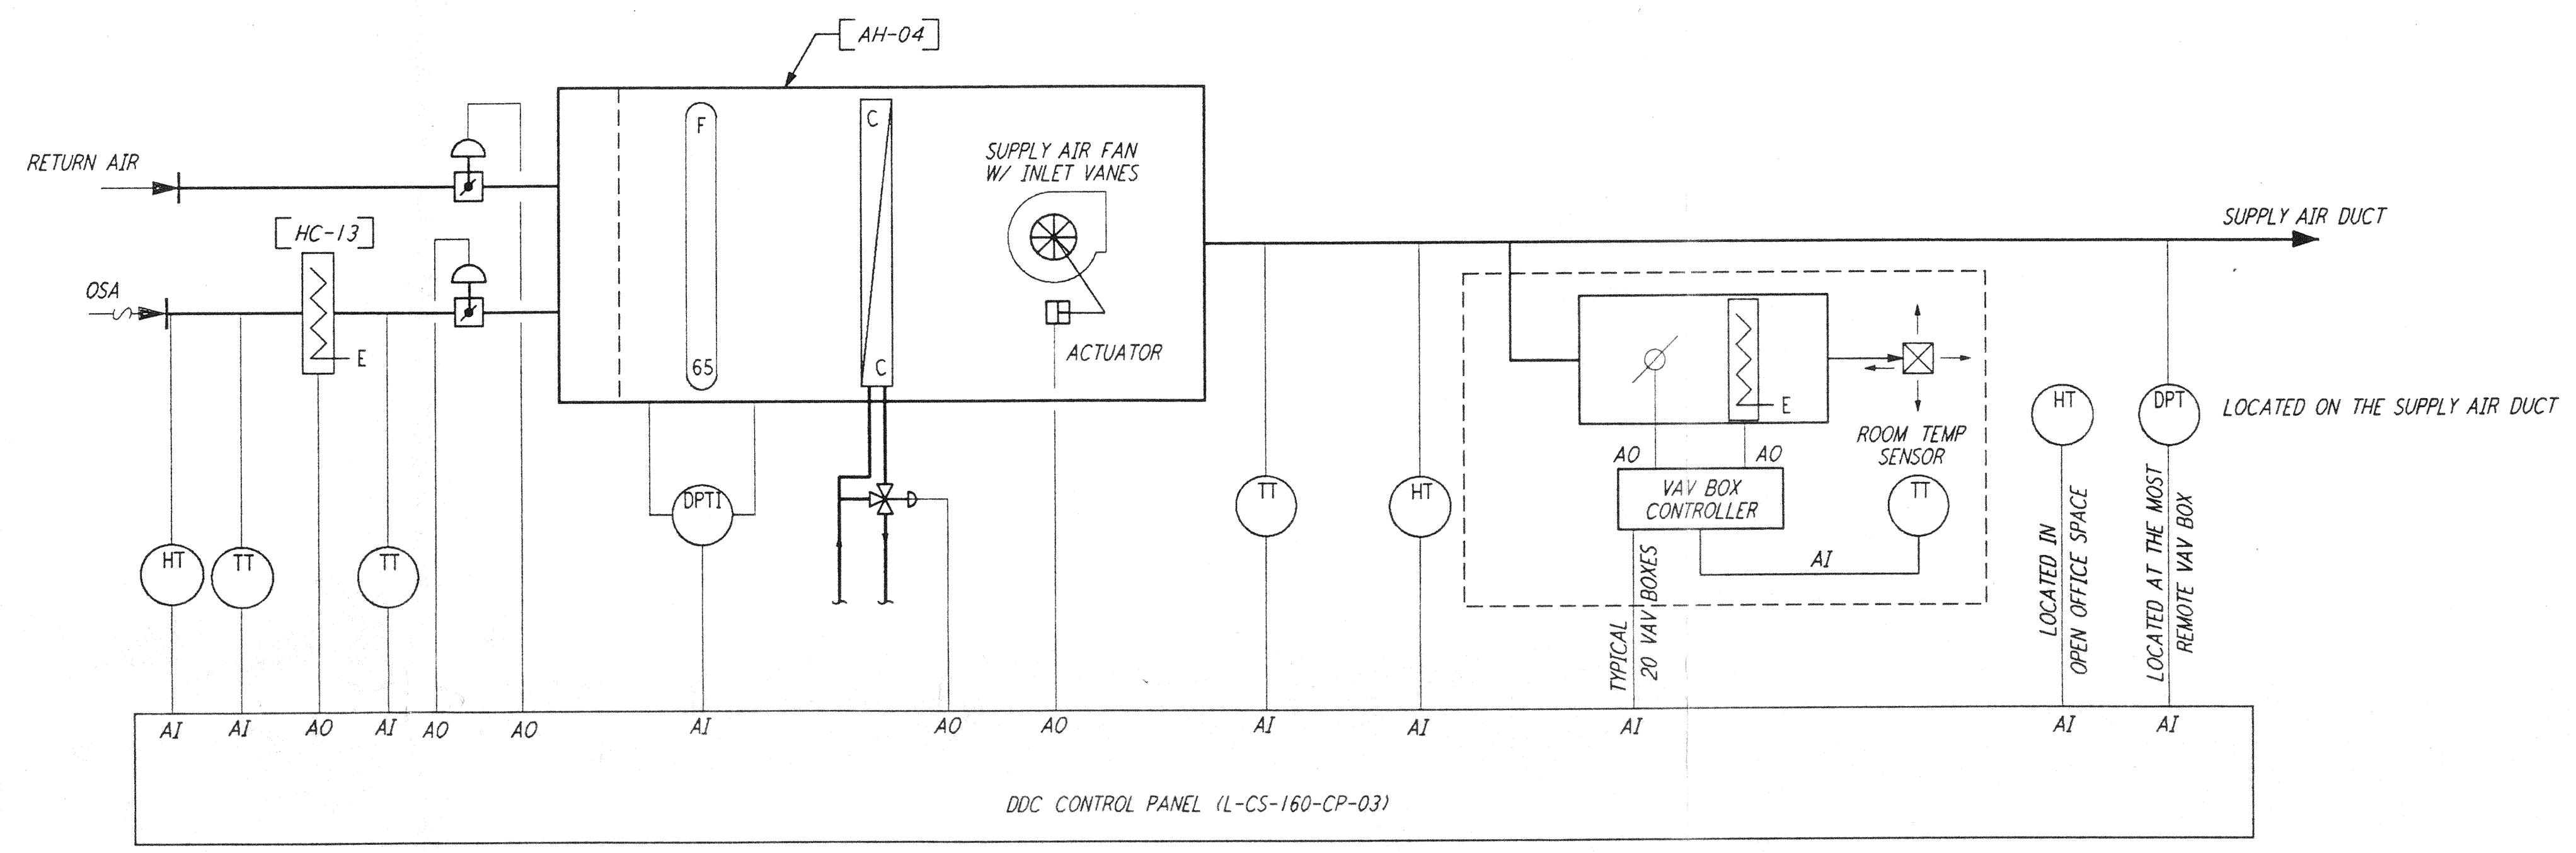


OSB AIR FLOW & CONTROL DIAGRAM  
(OFFICES AREA)

not be reproduced, copied, loaned, exhibited, or used in any other way, except by written consent from PARSONS to the borrower.

This document and the design it covers are the property of PARSONS. They are loaned only with the borrower's expressed written agreement that they will

NO.	DATE	BY	CHKD	ENGR	PROJ	DESCRIPTION

ISSUED FOR CONSTRUCTION	
DRAWN	CLP 11-15-96
CHECKED	MZ 10-25-96
ENGINEER	AA 10-23-96
PROJ	SOPH 11/15/96

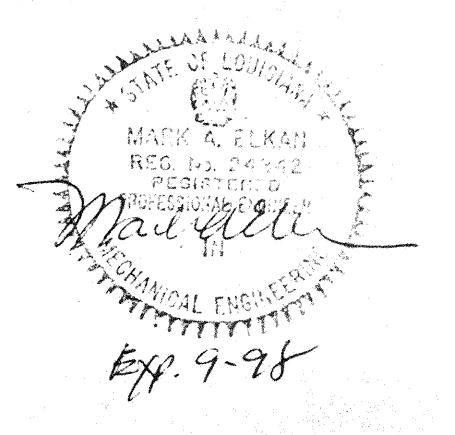

**PARSONS**  
 100 WEST WALNUT STREET  
 PASADENA, CALIFORNIA

**LIGO**  
 CALIFORNIA INSTITUTE OF TECHNOLOGY  
 MASSACHUSETTS INSTITUTE OF TECHNOLOGY

LASER INTERFEROMETER  
 GRAVITATIONAL-WAVE OBSERVATORY  
 SITE NO. 2 - LIVINGSTON, LOUISIANA

TITLE	SCALE	CONTRACT NUMBER	PROJECT NUMBER
HVAC CORNER STATION AIR FLOW DIAGRAMS SHEET 2	NONE	PPI50969	8094
SHEET NUMBER		REVISIONS	
<b>LA-H-123</b>			