



NOTES:


1. FOR LEGEND, ABBREVIATIONS AND GENERAL NOTES SEE SHEET LA-H-001 AND LA-H-002.
2. SEE INPUT/OUTPUT SUMMARY SHEETS, SHEETS LA-H-141 AND LA-H-142 FOR ALARMS AND EQUIPMENT CONTROL.

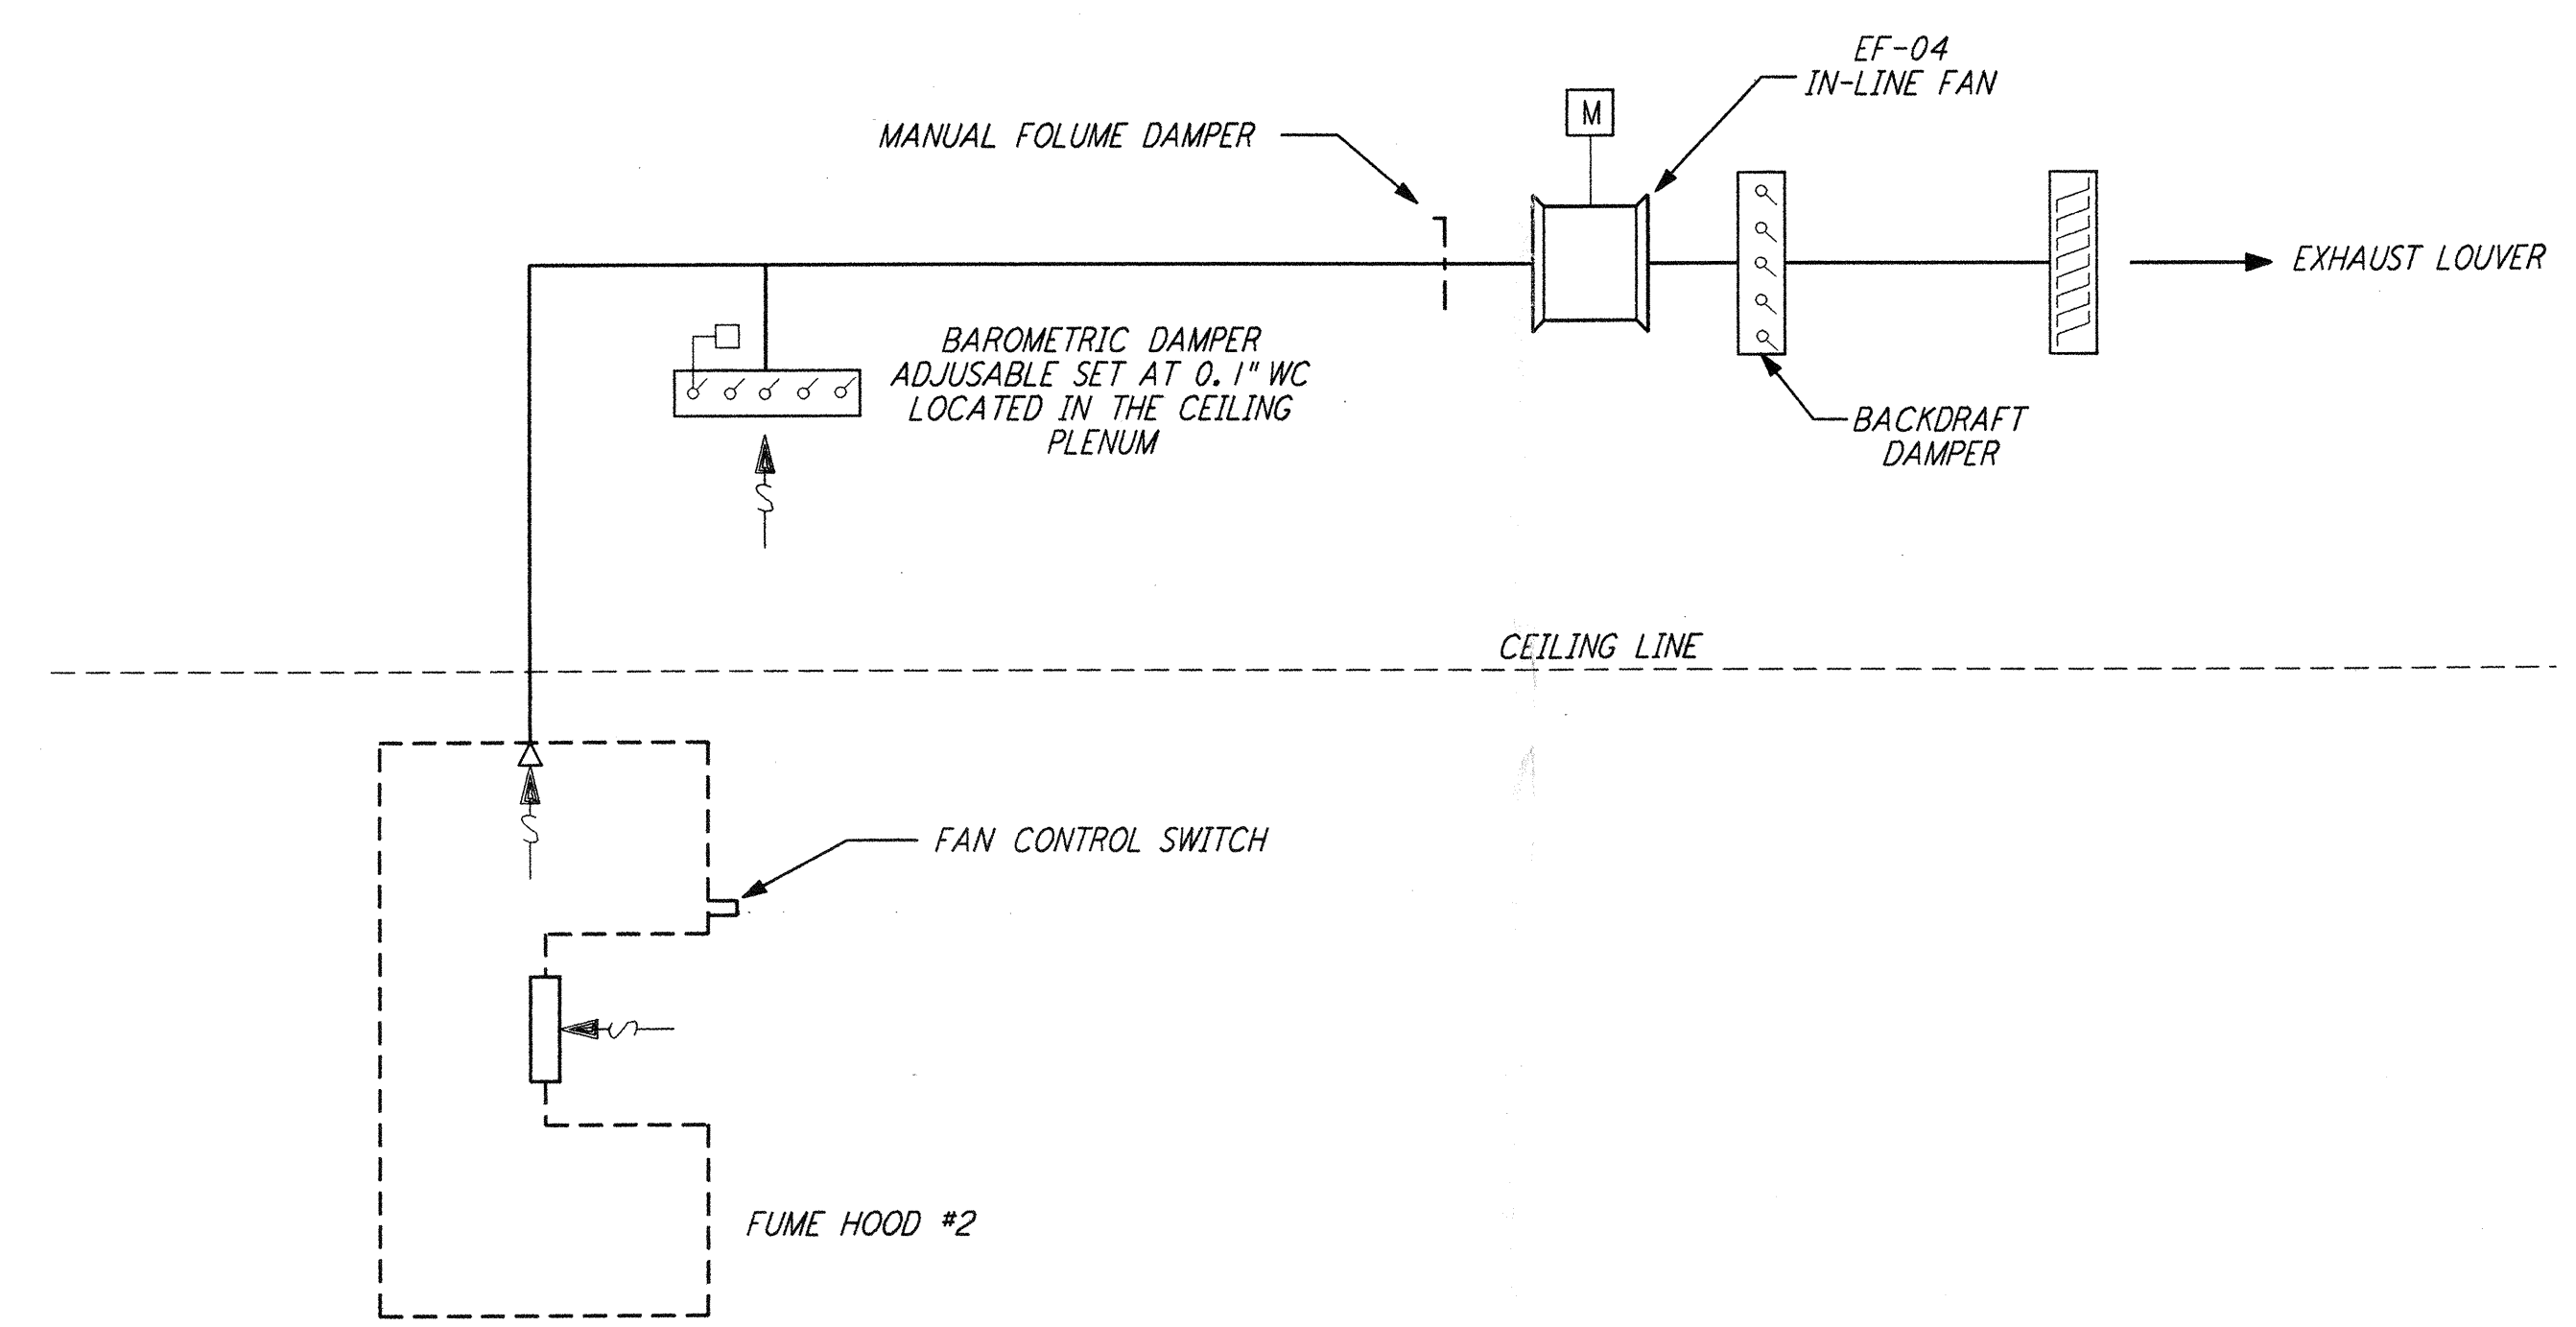

VACUUM PREPARATION FUME HOOD CONTROL DIAGRAM

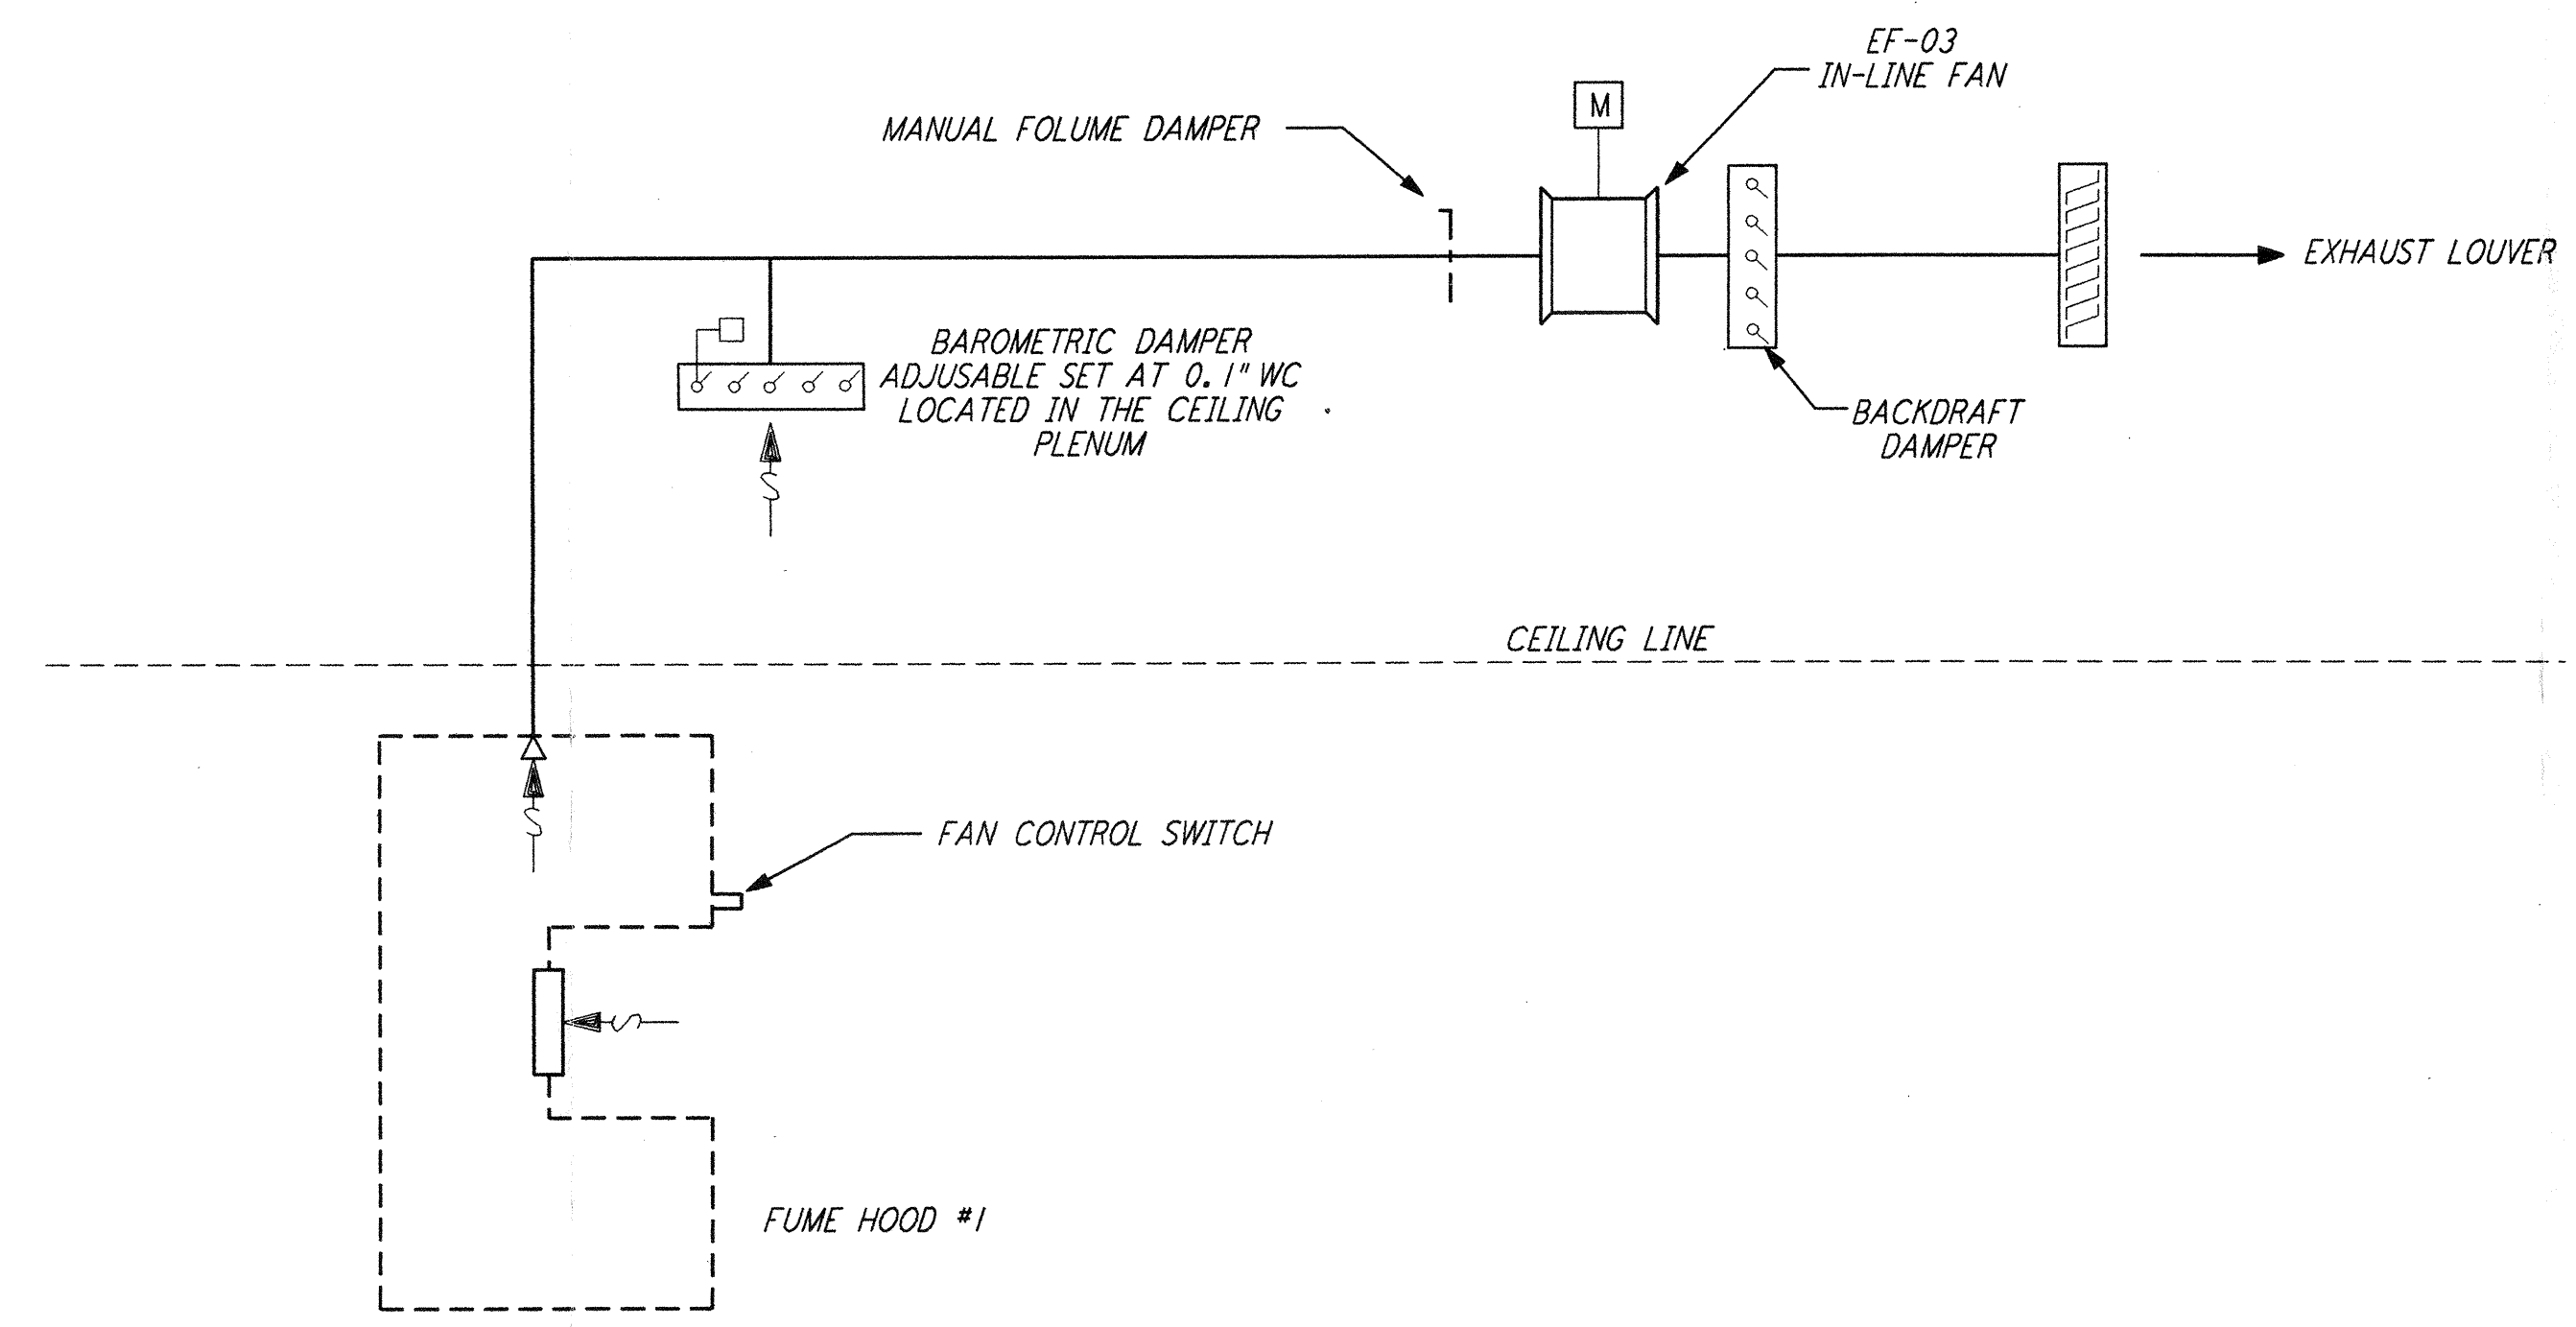

OPTICS LAB FUME HOOD CONTROL DIAGRAM

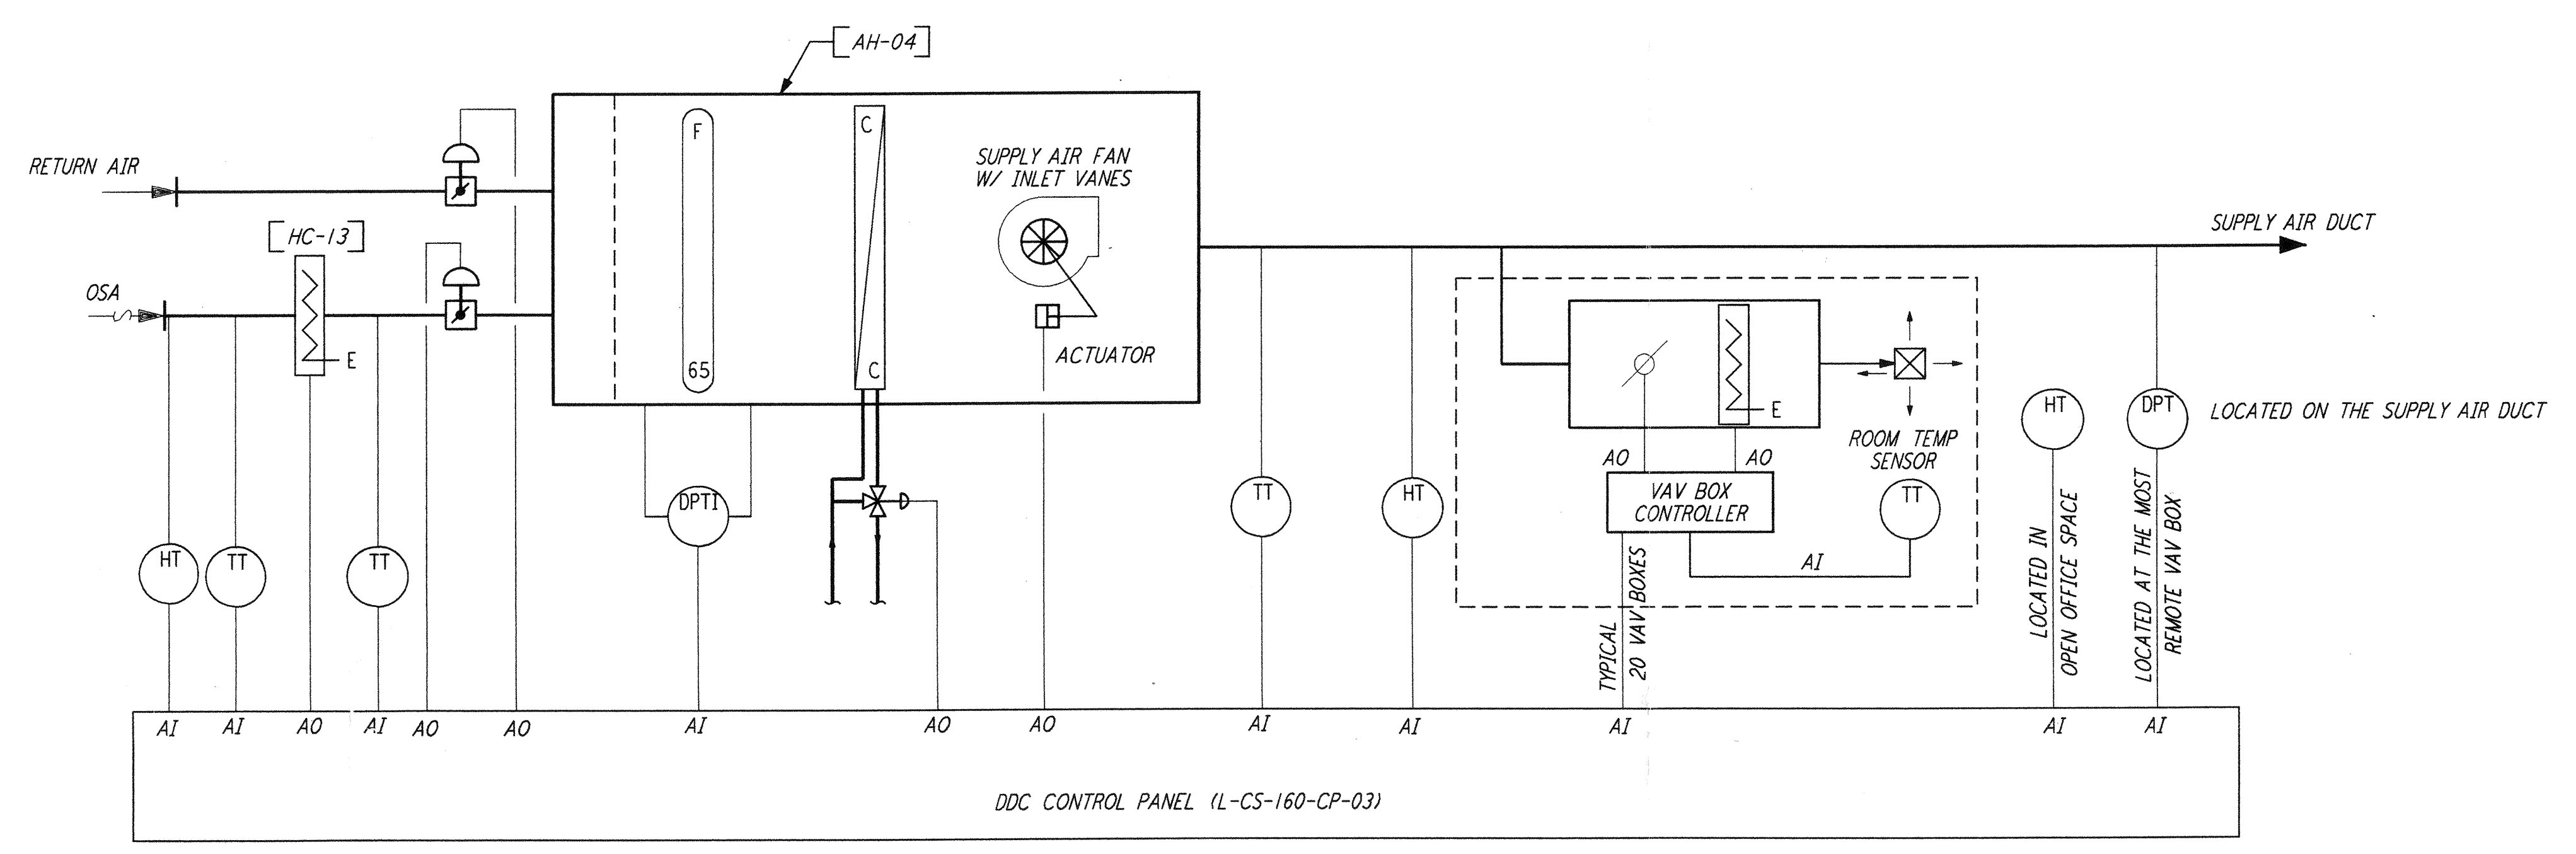

OSB AIR FLOW & CONTROL DIAGRAM
(OFFICES AREA)

not be reproduced, copied, loaned, exhibited, or used in any other way, except by written consent from PARSONS to the borrower.

This document and the design it covers are the property of PARSONS. They are loaned only with the borrower's expressed written agreement that they will

LIGO-D960976-01-0

LASER INTERFEROMETER
 GRAVITATIONAL-WAVE OBSERVATORY
 SITE NO.2 - LIVINGSTON, LOUISIANA

NO.	DATE	BY	CHKD	ENGR	PROJ	DESCRIPTION
1	8-7-98	DJB	AA	AA	MMW	ISSUED FOR AS-BUILT

ISSUED FOR CONSTRUCTION	DRAWN	CLP	11-15-96
CHECKED	MN	10-25-96	
ENGINEER	AA	1-23-96	
PROJ	TDM	11-15-96	

**AS-BUILT
DRAWINGS**

PARSONS
 100 WEST WALNUT STREET
 PASADENA, CALIFORNIA

LIGO
 CALIFORNIA INSTITUTE OF TECHNOLOGY
 MASSACHUSETTS INSTITUTE OF TECHNOLOGY

TITLE	SCALE	CONTRACT NUMBER	PROJECT NUMBER
HVAC CORNER STATION AIR FLOW DIAGRAMS SHEET 2	NONE	PP150969	8094
SHEET NUMBER		REVISIONS	
LA-H-123			