 



**NOTES:**

1. FOR GENERAL NOTES, AND LEGEND SEE DWG. LA-E-110.

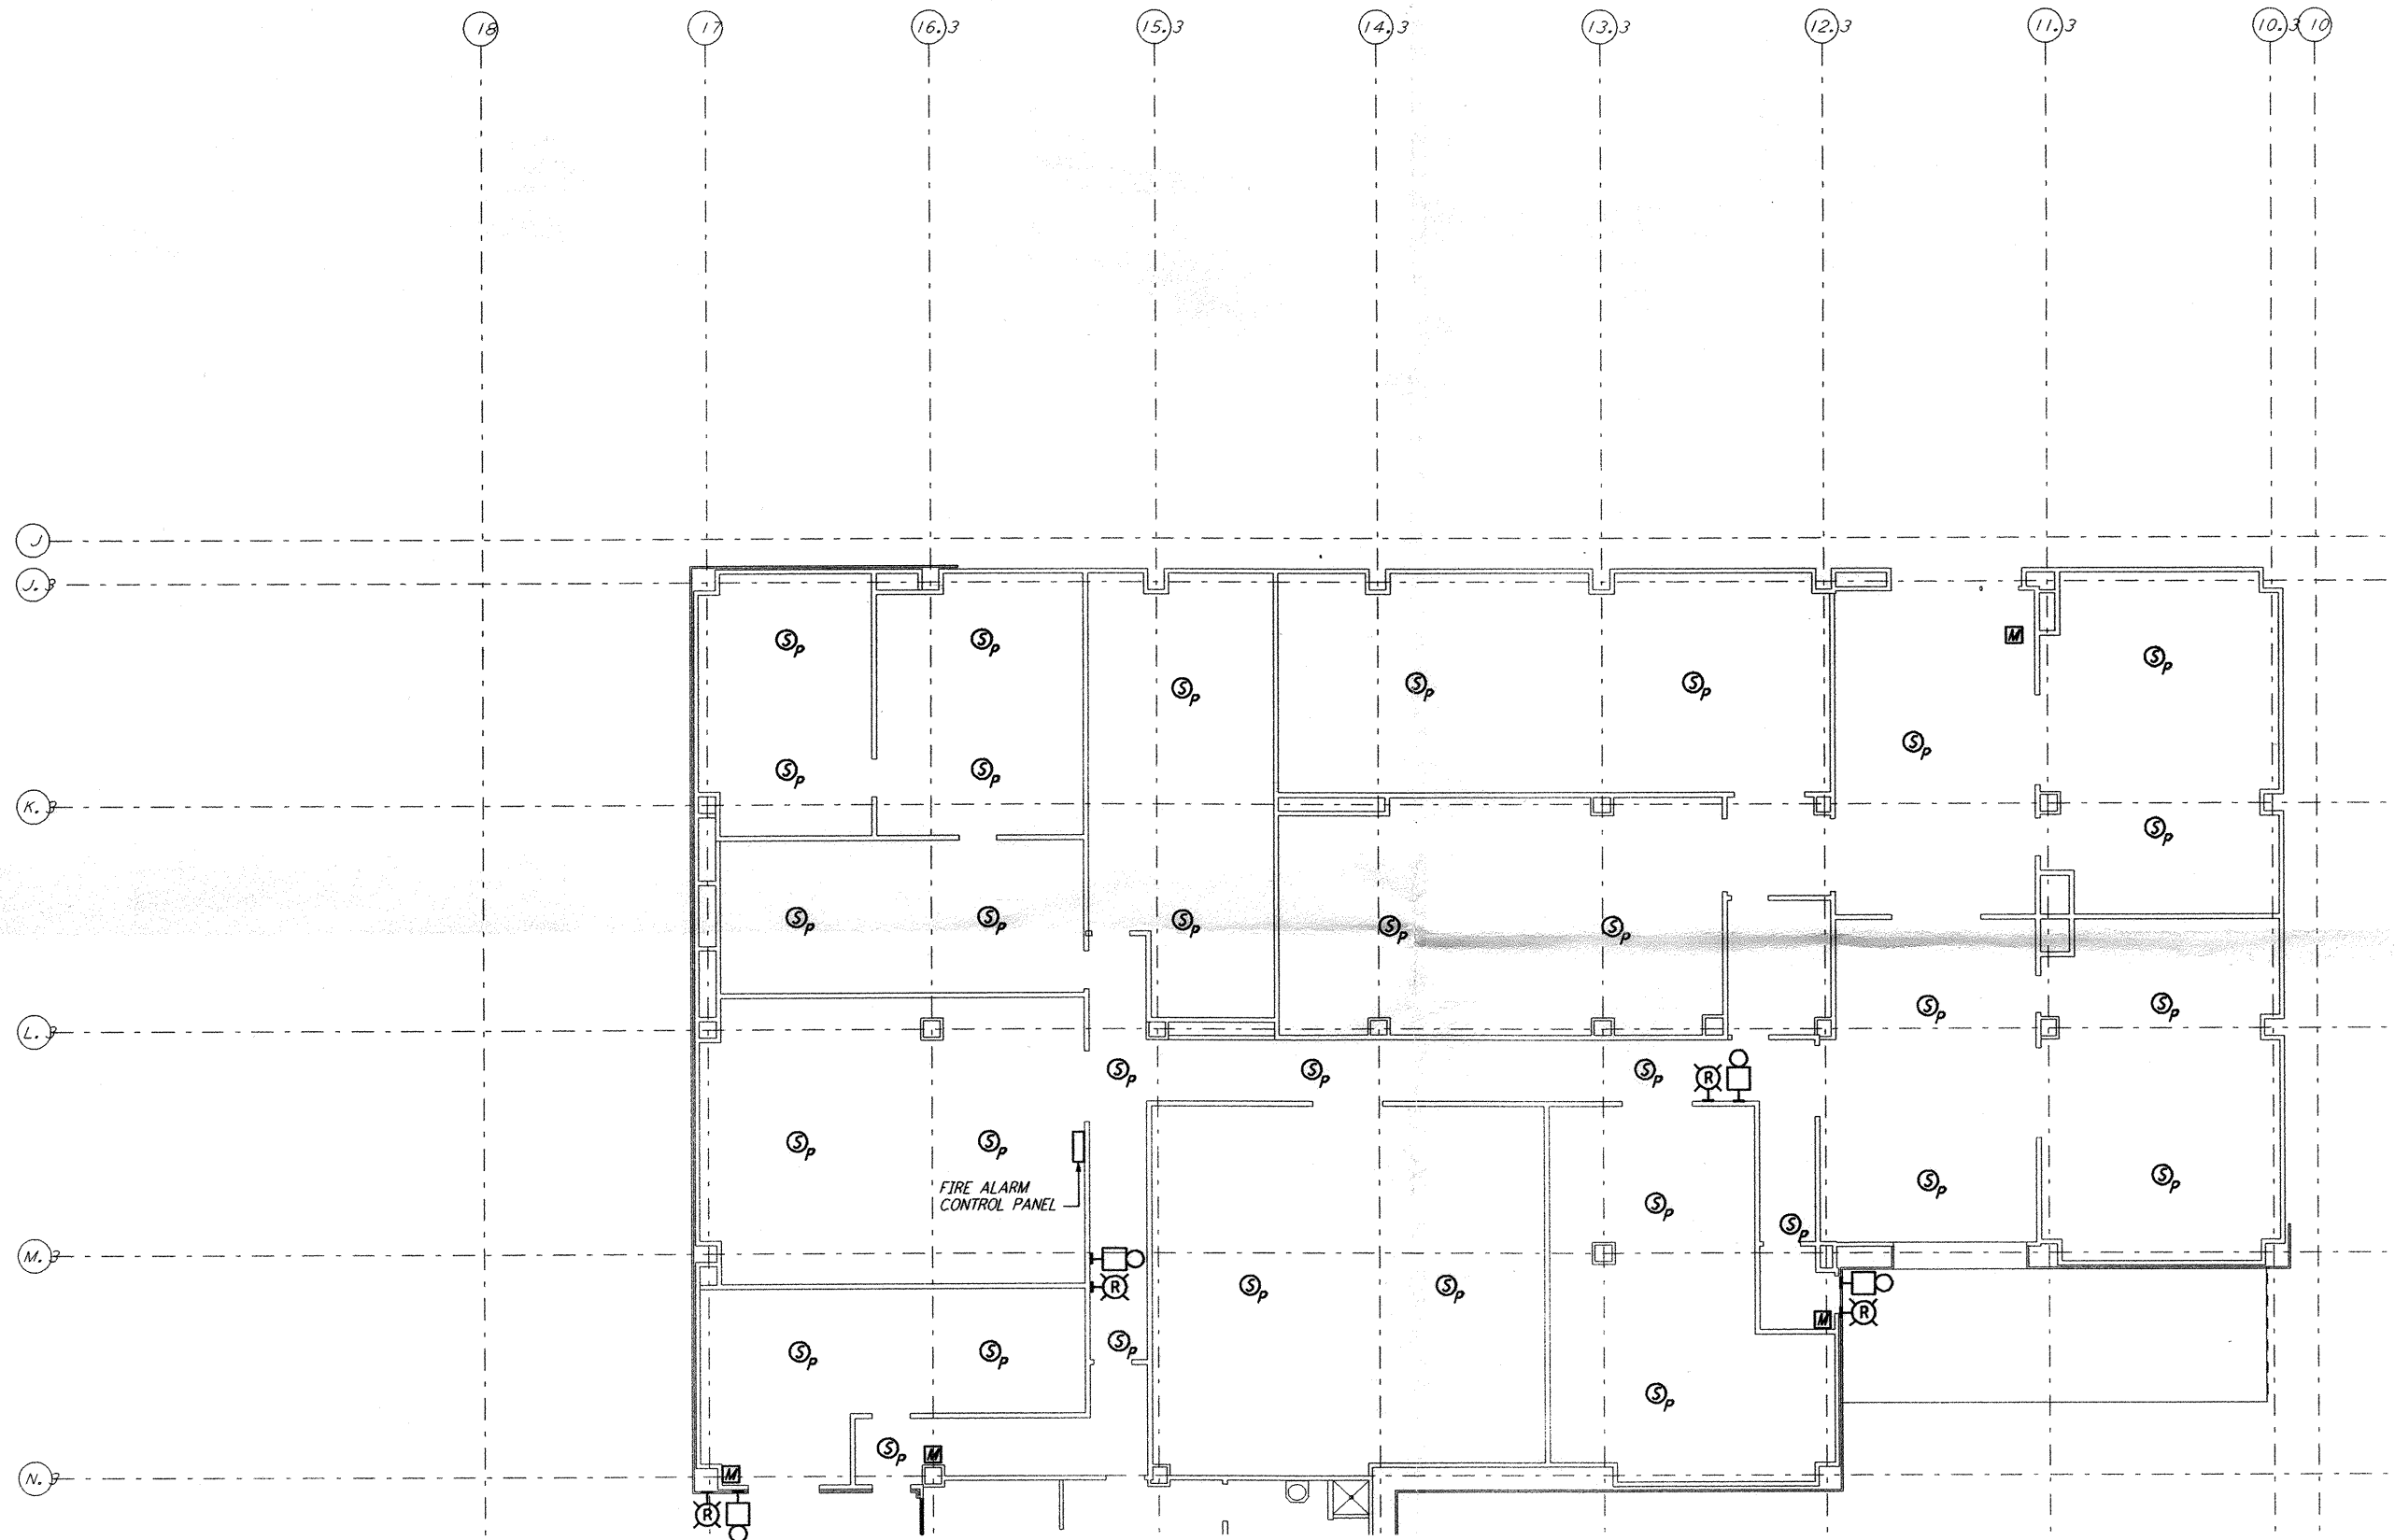

LIGO-D961013-A-0

NO.	DATE	APPRO BY	DESCRIPTION OF REVISION
9			
8			
7			
6			
5			
4			
3			
2			
1			

ISSUE	NO.	DATE	APPRO BY	DESCRIPTION
J				
H				
G				
F				
E				
D				
C				
B				
A	10-31-95	TDM		PRELIMINARY DESIGN REVIEW

DATE	10-31-95
DRAWN	J. G.
CHECKED	
ENGINEER	
PROJ MGR	

**PARSONS**  
 100 WEST WALNUT STREET  
 PASADENA, CALIFORNIA

**LIGO**  
 CALIFORNIA INSTITUTE OF TECHNOLOGY  
 MASSACHUSETTS INSTITUTE OF TECHNOLOGY

LASER INTERFEROMETER  
 GRAVITATIONAL-WAVE OBSERVATORY  
 SITE NO. 2 - LIVINGSTON, LOUISIANA

TITLE	ELECTRICAL CORNER STATION OSB LAB AREA FIRE DET AND SECURITY PLAN	AS NOTED	PP150969	8094
SHEET NUMBER	LA-E-111	REVISIONS		

This document and the design it covers are the property of PARSONS. They are loaned only with the borrower's expressed written agreement that they will not be reproduced, copied, loaned, exhibited, or used in any other way, except by written consent from PARSONS to the borrower.

This document and the design it covers are the property of PARSONS. They are loaned only with the borrower's expressed written agreement that they will not be reproduced, copied, loaned, exhibited, or used in any other way, except by written consent from PARSONS to the borrower.

Tue Oct 31 01:30:36 1995 s3-v18b2 J:\PLOTS\QUEUES\18B2\EE111B.PRF