 

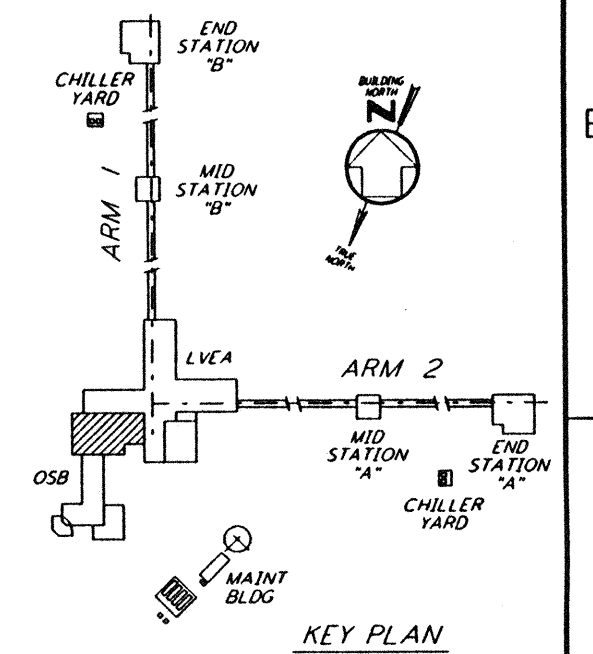


NOTES:

1. FOR PLAN SYMBOLS SEE DWG LA-E-002.
2. WIRING FOR FIRE DETECTION SHALL BE CLASS "A". FOR FIRE ALARM DEVICES SHALL BE CLASS "B". WIRING INSTALLED IN CONCEALED CONDUIT FOR FIRE DETECTION AND SECURITY SYSTEMS SHALL BE DONE BY OTHERS.
3. DUCT MOUNTED SMOKE DETECTORS SHALL BE PROVIDED WITH AN AUXILIARY RELAY CONTACT (N.C.) FOR EQUIPMENT SHUT-DOWN.
4. COORDINATE SMOKE DETECTOR LOCATIONS WITH CLEAN AGENT DISCHARGE NOZZLES.
5. COORDINATE AHJ LOCATIONS WITH DUCT MOUNTED SMOKE DETECTORS.

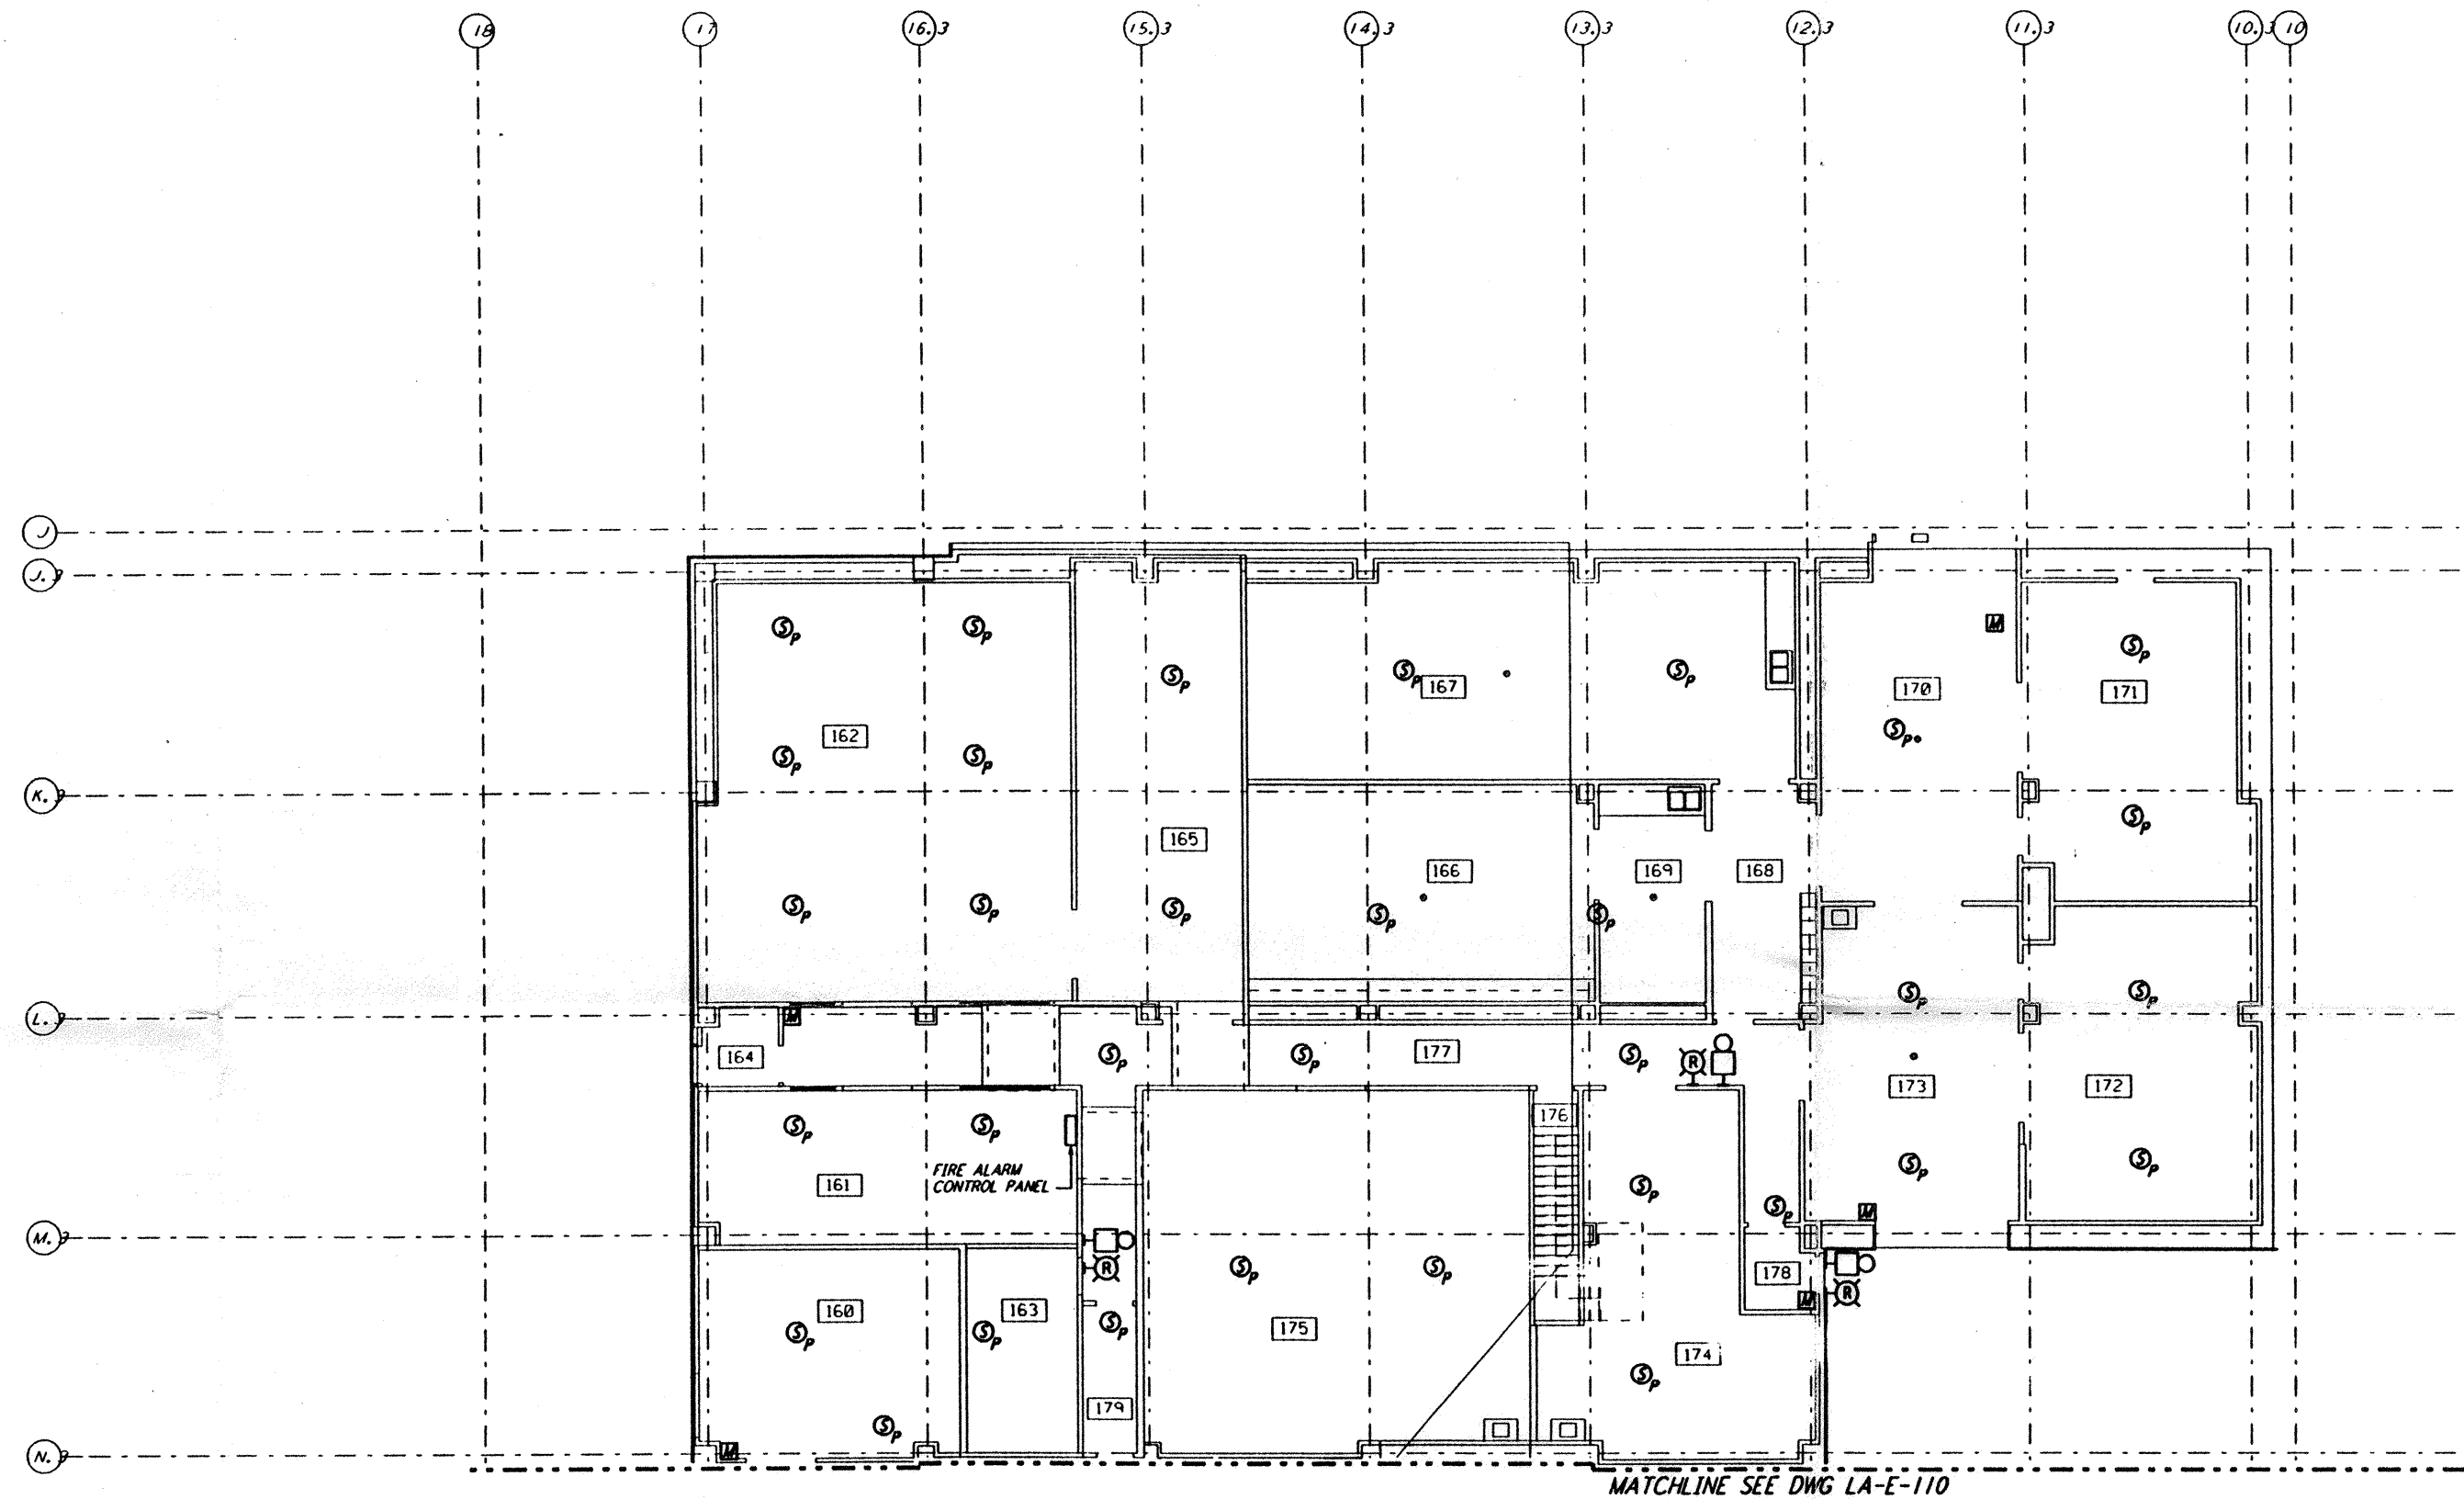

This document and the design it covers are the property of PARSONS. They are loaned only with the borrower's expressed written agreement that they will not be reproduced, copied, loaned, exhibited, or used in any other way, except by written consent from PARSONS to the borrower.

| NO. | DATE | BY | CHKD | ENGR | PROJ | DESCRIPTION |
|-----|----------|----|------|------|------|---------------------------|
| C | 7-24-96 | MM | JCL | TDM | | ISSUED FOR BID |
| B | 6-14-96 | MM | JCL | RR | TDM | FINAL DESIGN REVIEW |
| A | 10-31-95 | | | | TDM | PRELIMINARY DESIGN REVIEW |

| | |
|----------|-------|
| DRAWN | M. M. |
| CHECKED | |
| ENGINEER | |
| PROJ | |

PARSONS
 100 WEST WALNUT STREET
 PASADENA, CALIFORNIA

LIGO
 CALIFORNIA INSTITUTE OF TECHNOLOGY
 MASSACHUSETTS INSTITUTE OF TECHNOLOGY

**LASER INTERFEROMETER
 GRAVITATIONAL-WAVE OBSERVATORY
 SITE NO. 2 - LIVINGSTON, LOUISIANA**

| | | | |
|---|----------|-----------------|----------------|
| TITLE | AS NOTED | CONTRACT NUMBER | PROJECT NUMBER |
| ELECTRICAL CORNER DATE OSB LAB AREA FIRE DET & SECURITY PLAN | | PP150969 | 8094 |
| DRAWING NO. | LA-E-111 | | REVISION |
| 5 | 1 | | |

Tue Jul 23 16:42:03 1996 s3-v18b2 J:\PLOTS\QUEUES\18B2\EE111.PR