

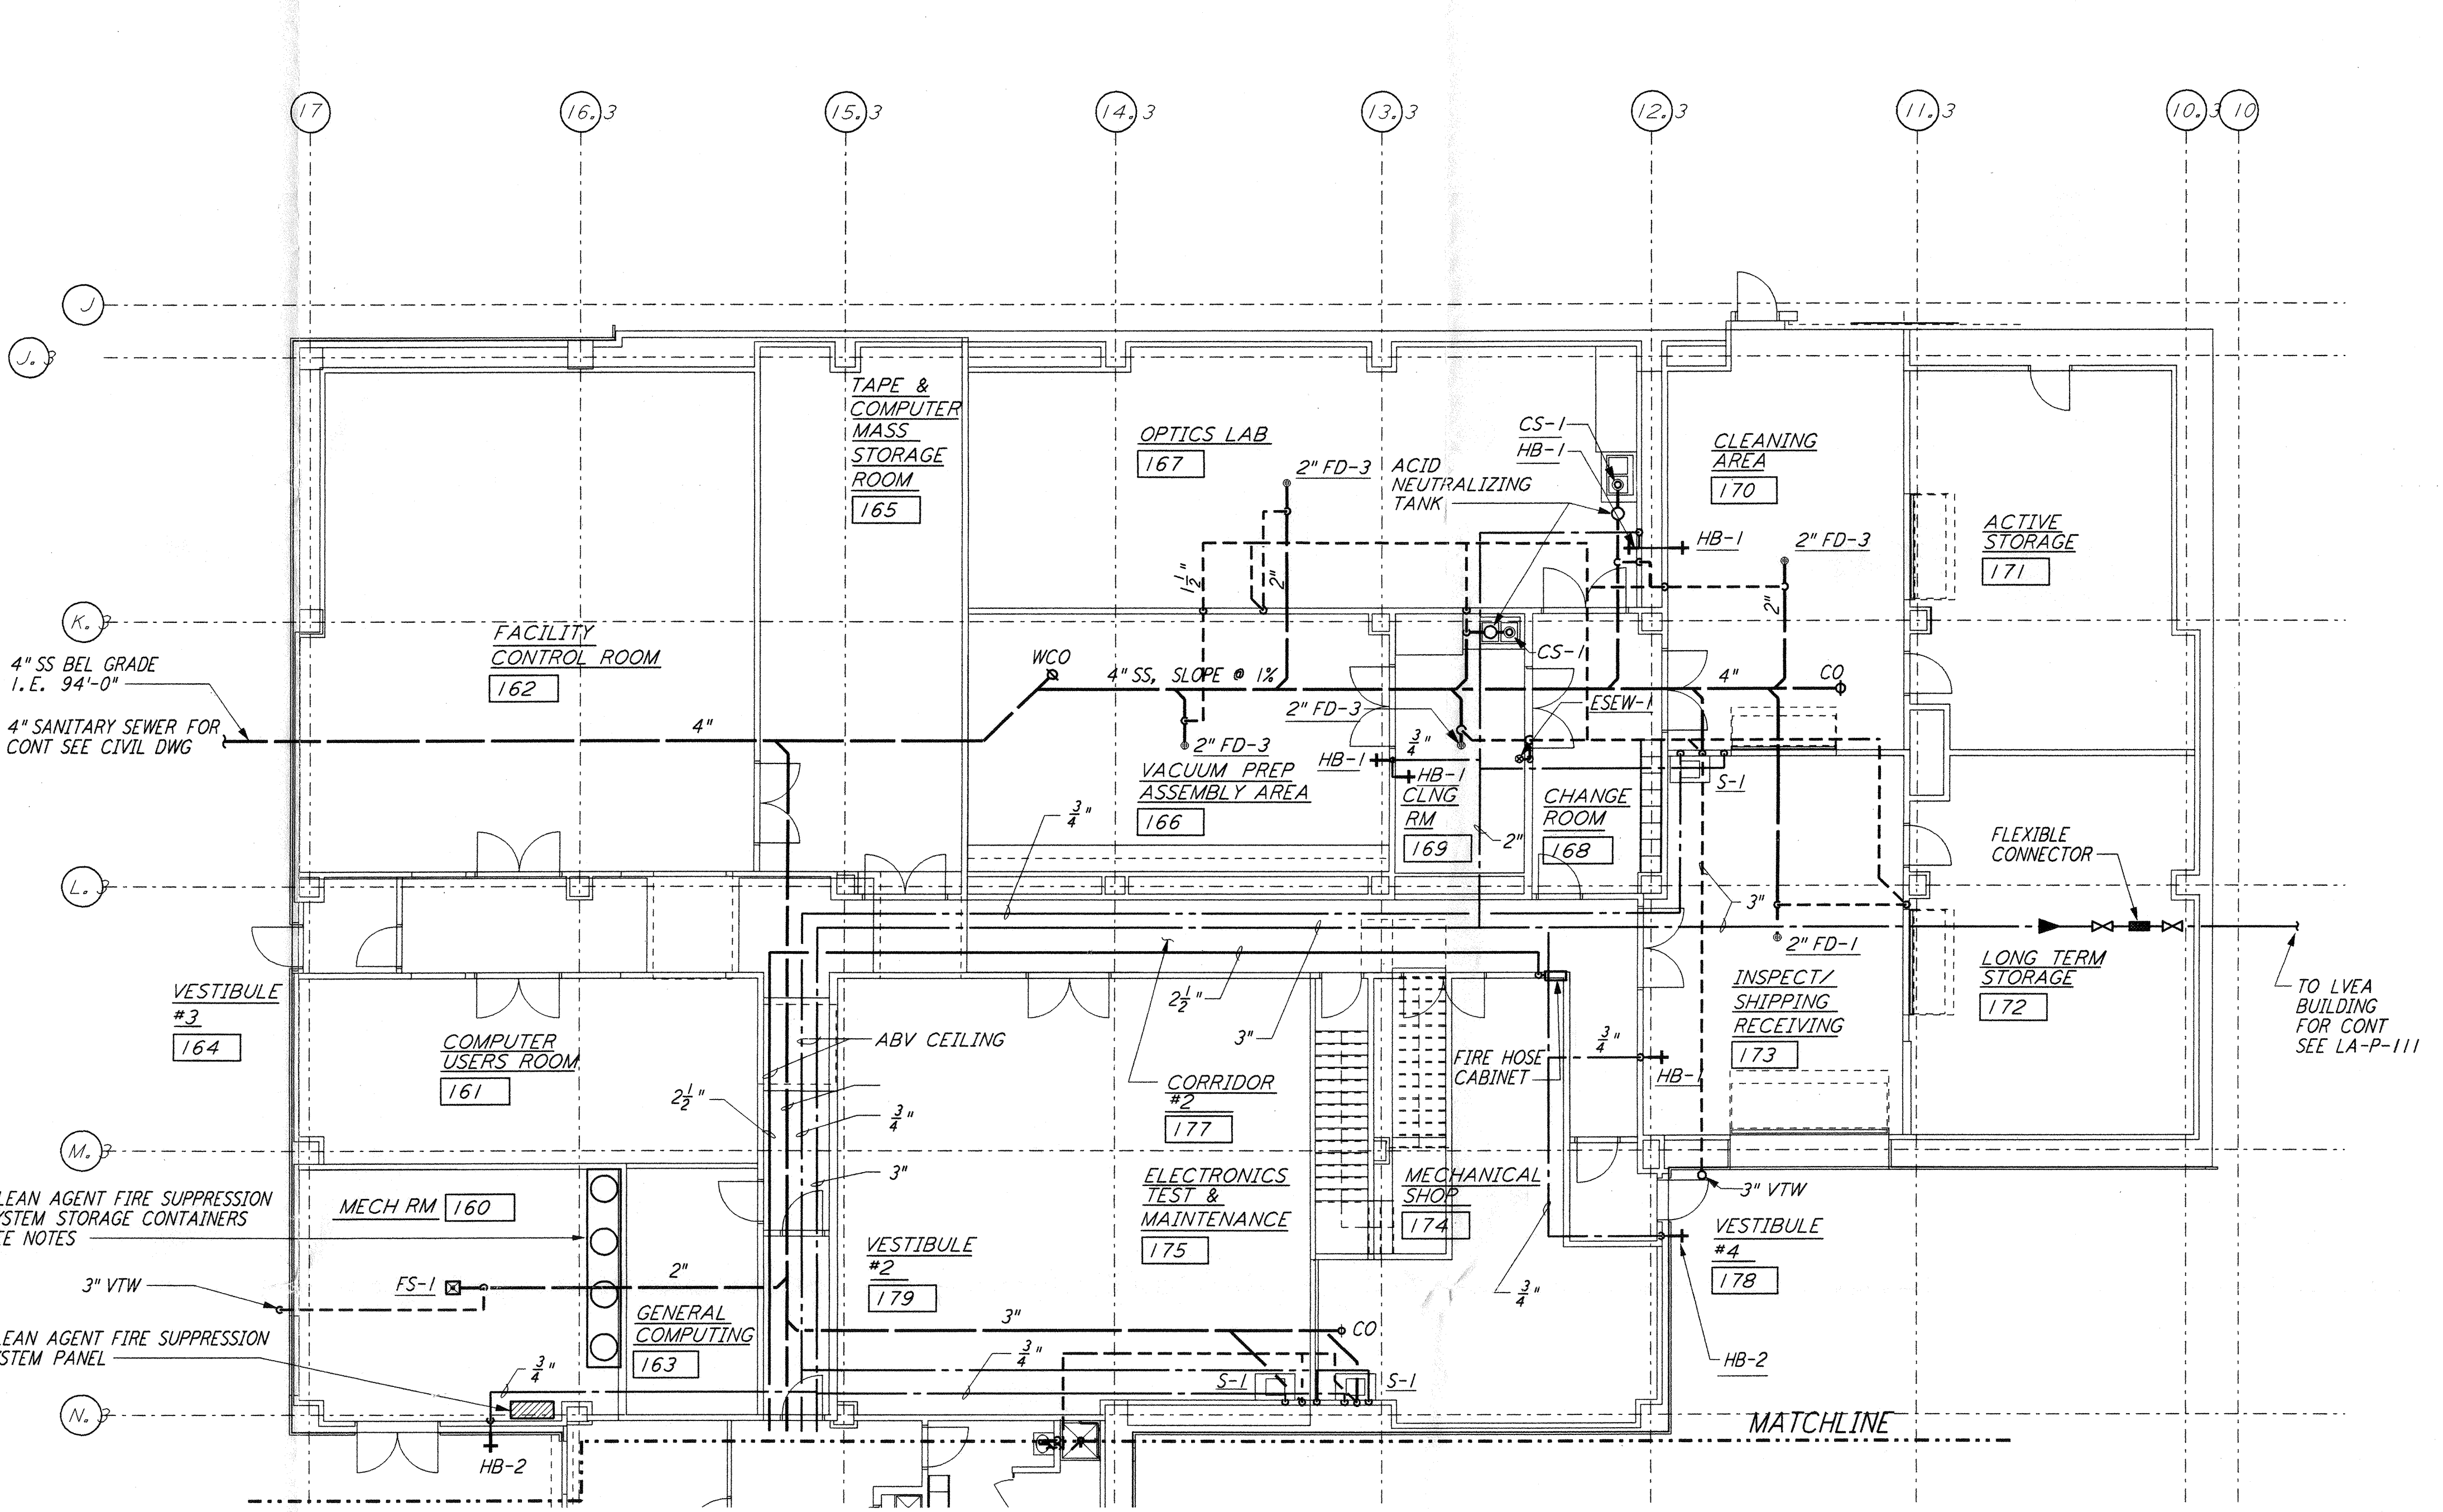
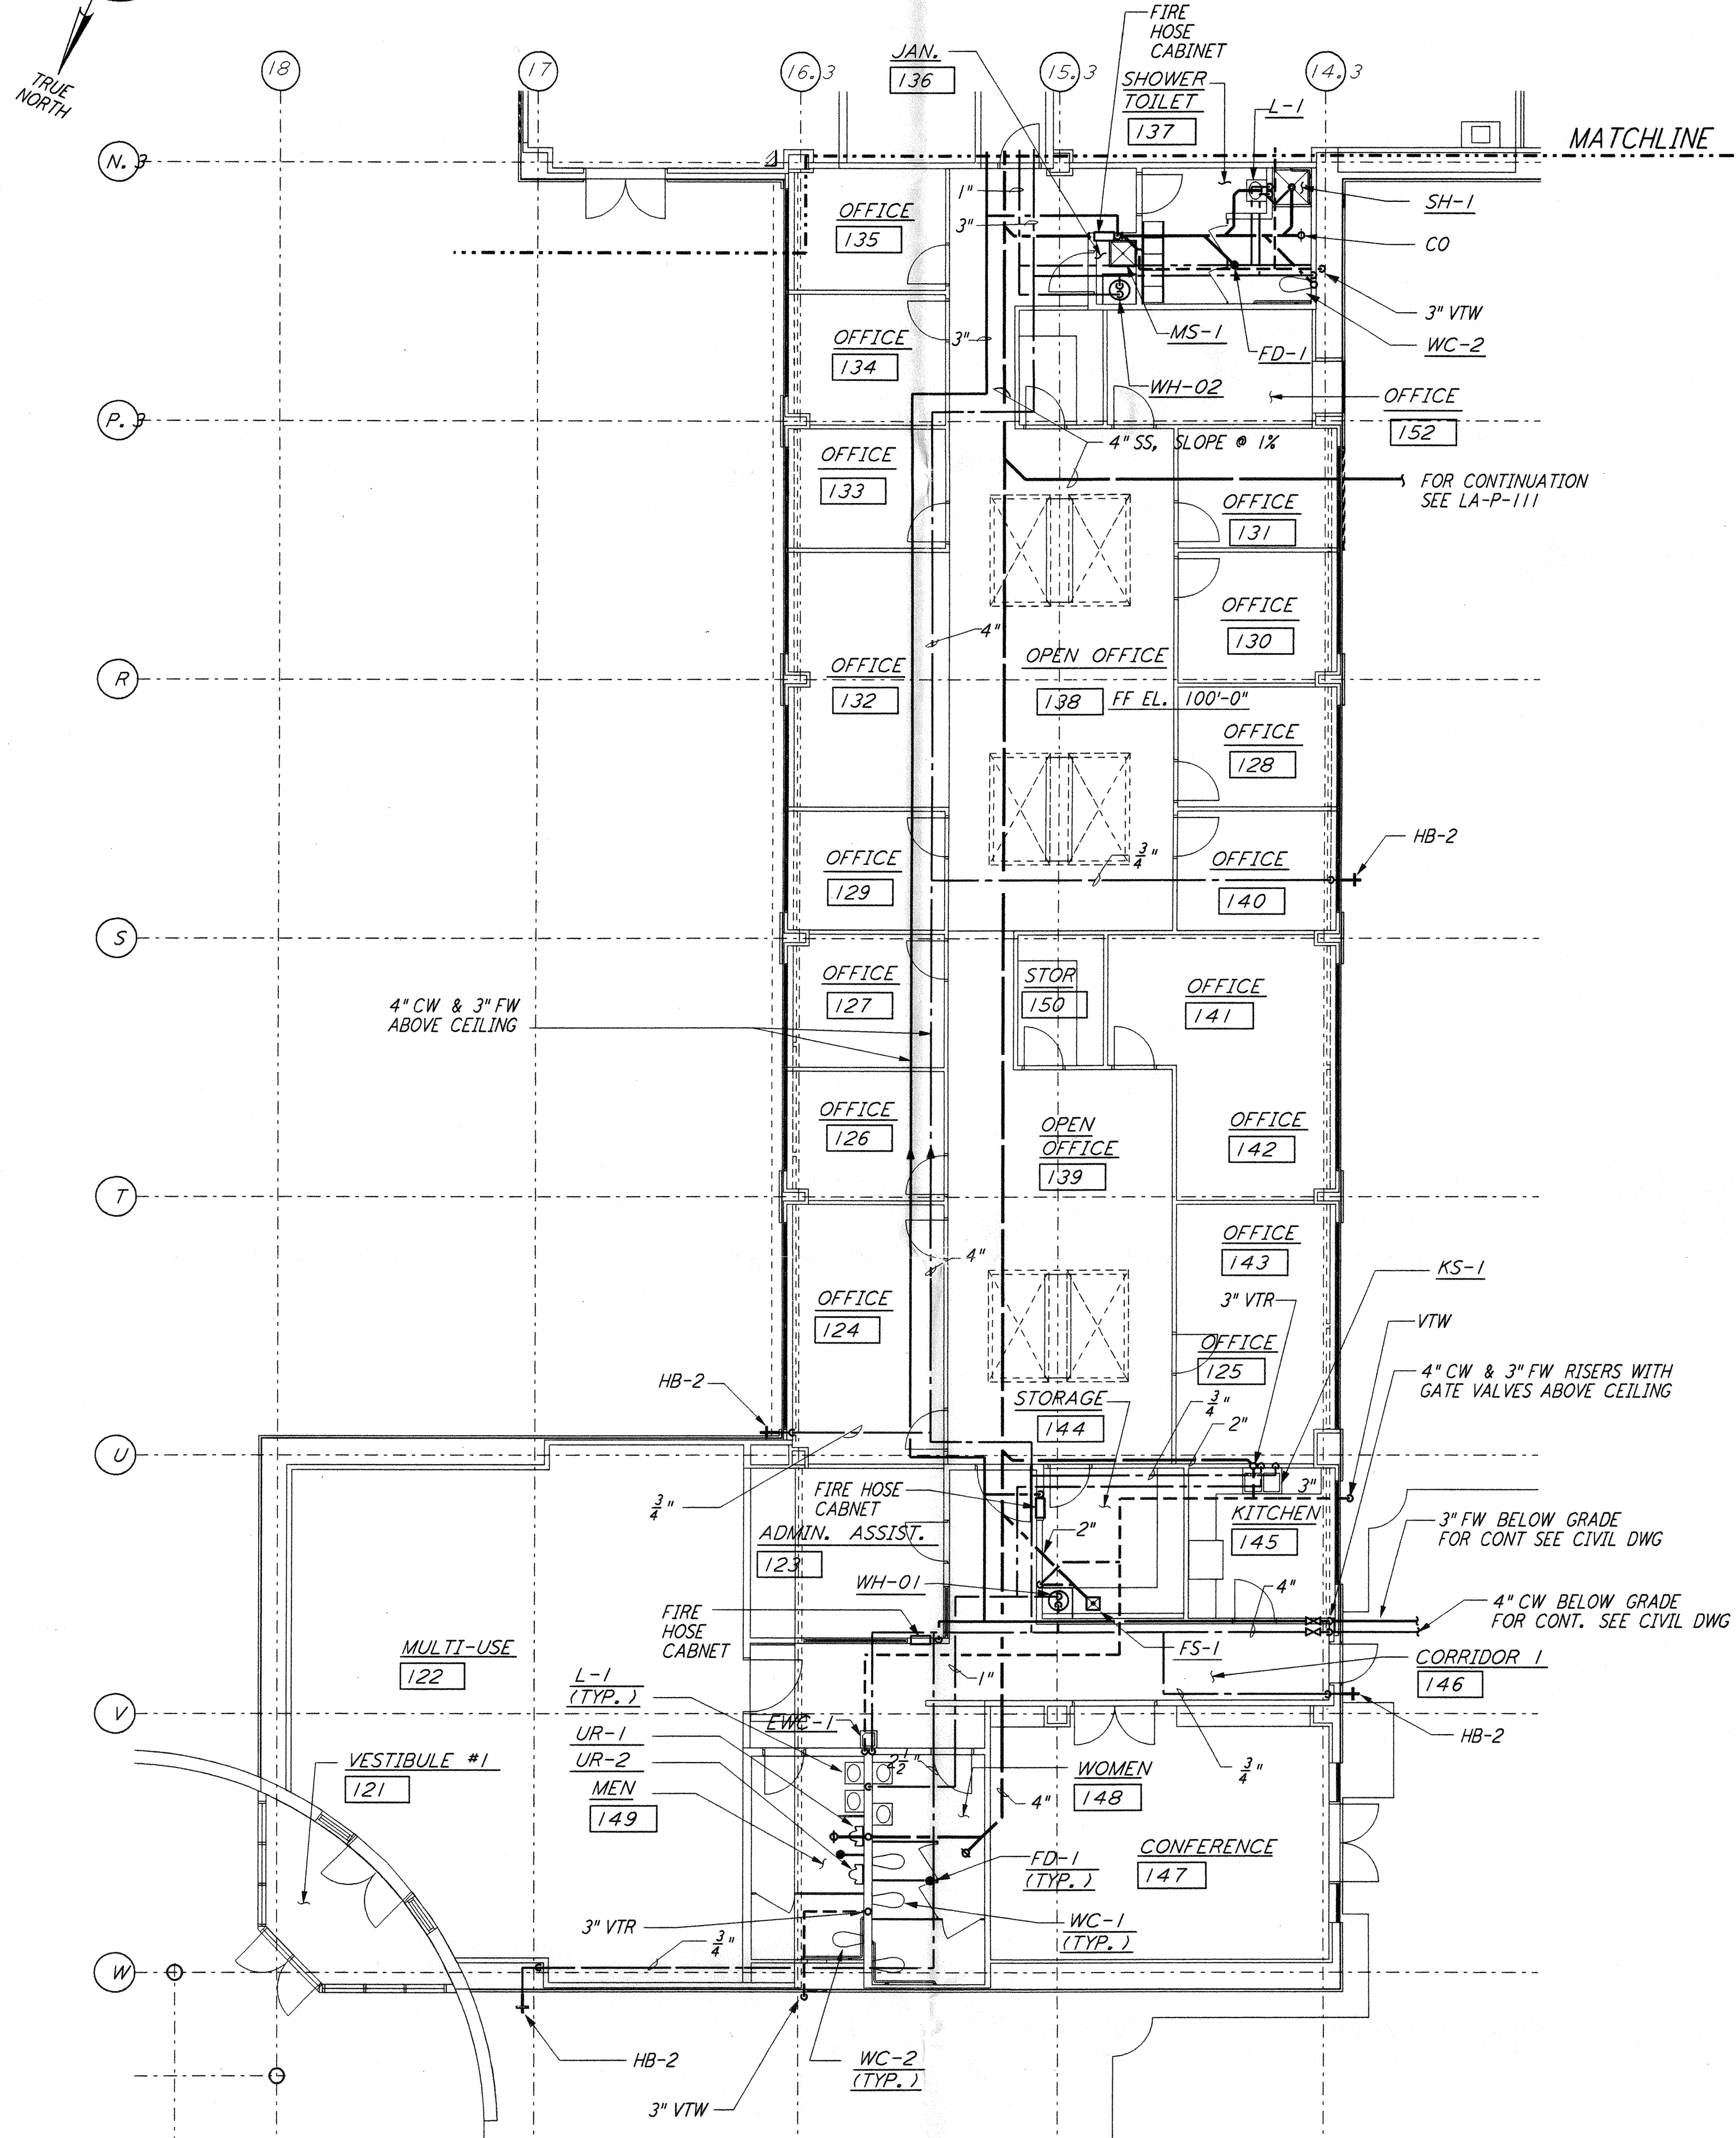


This document and the design it covers are the property of PARSONS. They are loaned only with the borrower's expressed written agreement that they will not be reproduced, copied, loaned, exhibited, or used in any other way, except by written consent from PARSONS to the borrower.

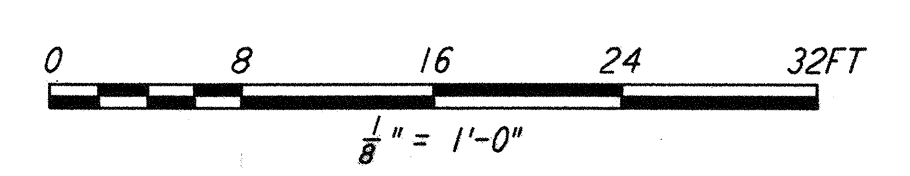

4" SS BEL GRADE
 I.E. 94'-0"
 4" SANITARY SEWER FOR
 CONT SEE CIVIL DWG

- NOTES:**
- A CLEAN AGENT FIRE SUPPRESSION SYSTEM SHALL BE PROVIDED ABOVE AND WITHIN THE DEPRESSED FLOOR SPACE, FOR THE FOLLOWING ROOMS:
 - A. FACILITY CONTROL ROOM [162]
 - B. TAPE & COMPUTER MASS STORAGE ROOM [165]
 - C. COMPUTER USERS ROOM [161]
 - D. GENERAL COMPUTING [163]
 - REFER TO THE PERFORMANCE TYPE SPECIFICATIONS FOR REQUIREMENTS AND DESIGN CRITERIA.

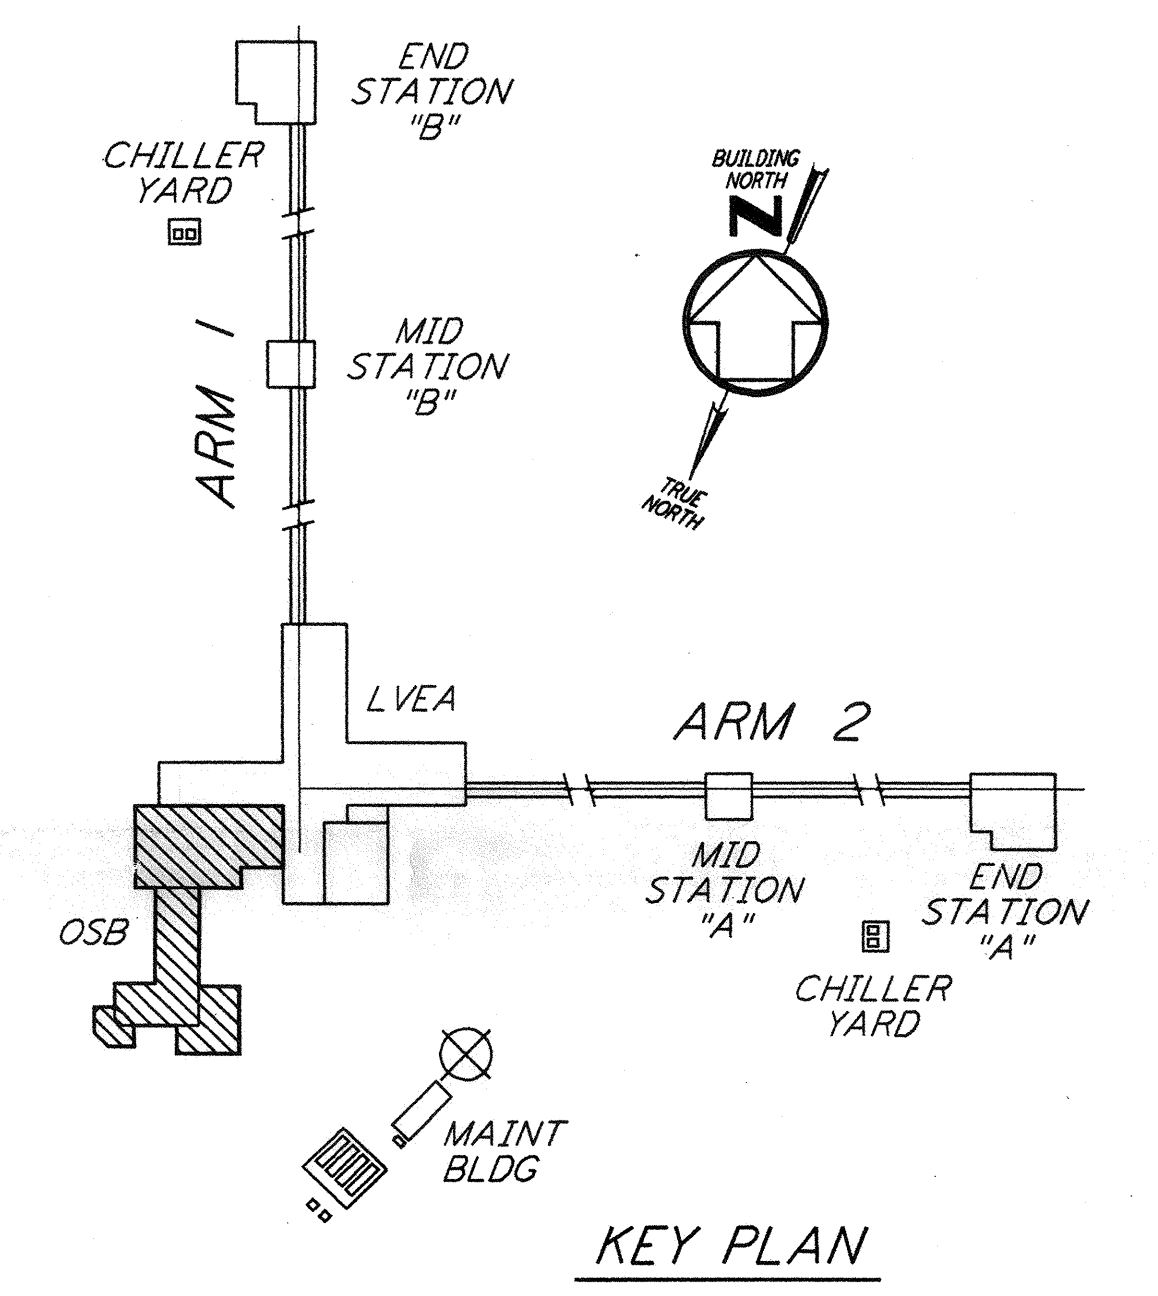

NO.	DATE	BY	CHKD	ENGR	PROJ	DESCRIPTION
2	8-7-98	DJB	TWP	AA	WV	ISSUED FOR AS-BUILT
1	3-20-97	WVK	AA	AA	TDM	REVISED PLUMBING PIPING LAYOUT

ISSUED FOR CONSTRUCTION	DG	11-15-96
DRAWN	ME	10-25-96
CHECKED	AA	10-25-96
ENGINEER	TDM	11-15-96
PROJ		

AS-BUILT DRAWINGS

PARSONS
 100 WEST WALNUT STREET
 PASADENA, CALIFORNIA

LIGO
 CALIFORNIA INSTITUTE OF TECHNOLOGY
 MASSACHUSETTS INSTITUTE OF TECHNOLOGY

LIGO-D961049-02-O
 LASER INTERFEROMETER
 GRAVITATIONAL-WAVE OBSERVATORY
 SITE NO. 2 - LIVINGSTON, LOUISIANA

TITLE	SCALE	CONTRACT NUMBER	PROJECT NUMBER
PLUMBING CORNER STATION OSB FLOOR PLAN	AS NOTED	PP150969	8094
SHEET NUMBER	LA-P-112		