


WASTE AND VENT RISER DIAGRAM

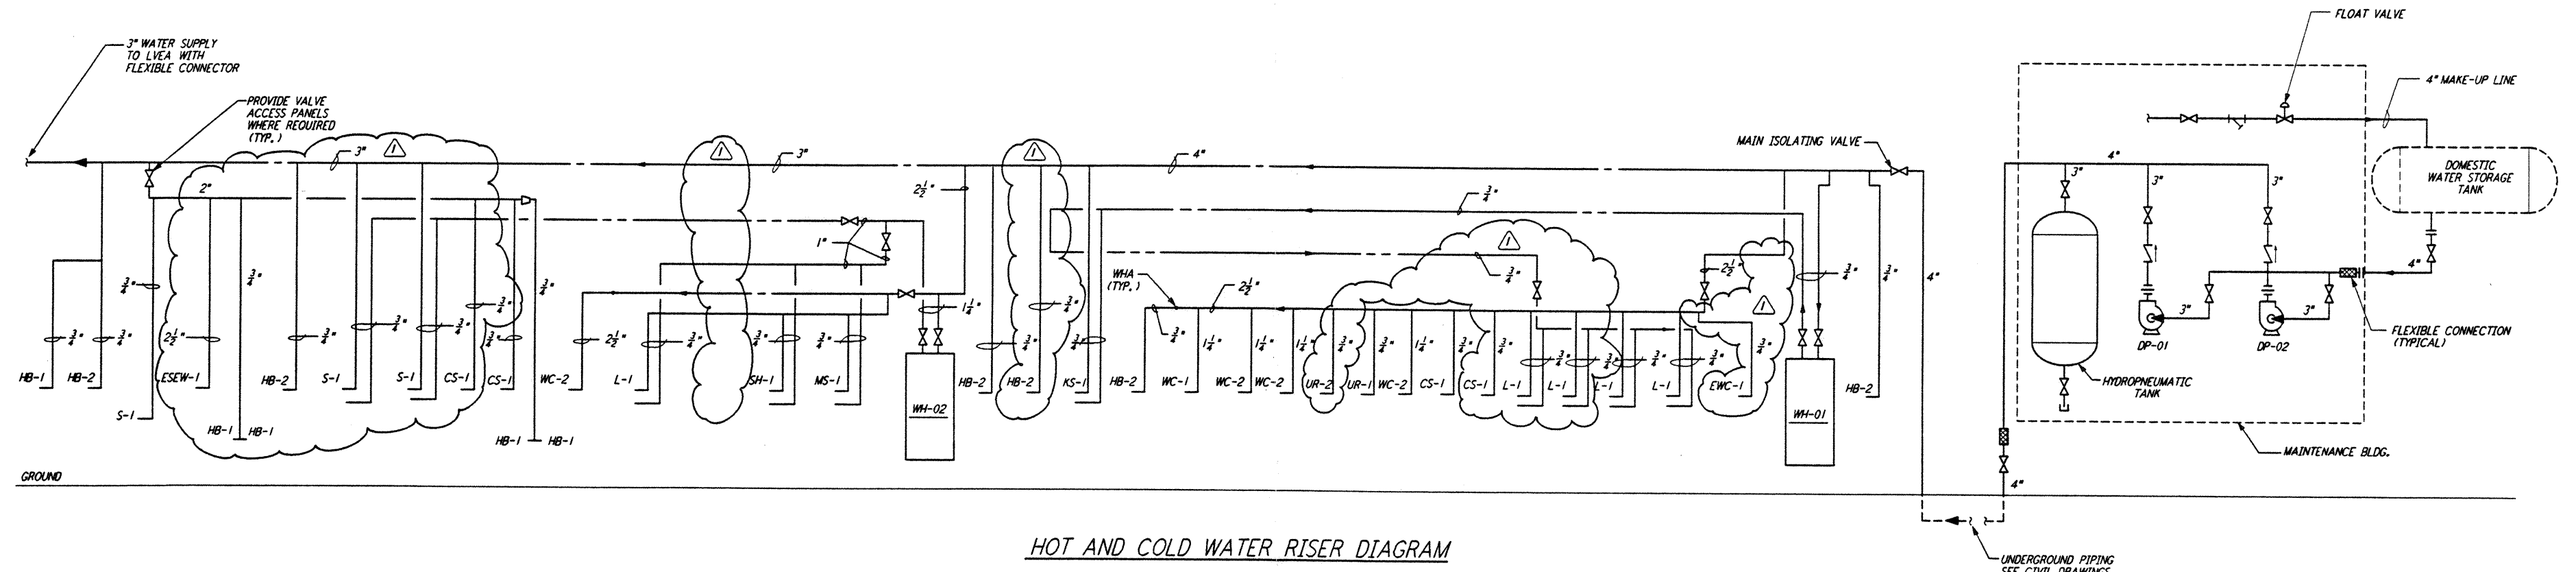


HOT AND COLD WATER RISER DIAGRAM

LIGO-D961051-01-0

NO.	DATE	BY	CHKD	ENGR	PROJ	DESCRIPTION
1	3-20-97	WVK	AA	AA	TDM	REVISED PLUMBING RISER DIAGRAMS

ISSUED FOR CONSTRUCTION		
DRAWN	DC	11-15-96
CHECKED	ME	10-25-96
ENGINEER	AA	10-25-96
PROJ	TDM	11-15-96

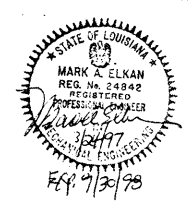

PARSONS
 100 WEST WALNUT STREET
 PASADENA, CALIFORNIA

LIGO
 CALIFORNIA INSTITUTE OF TECHNOLOGY
 MASSACHUSETTS INSTITUTE OF TECHNOLOGY

LASER INTERFEROMETER
 GRAVITATIONAL-WAVE OBSERVATORY
 SITE NO. 2 - LIVINGSTON, LOUISIANA

TITLE: PLUMBING CORNER STATION RISER DIAGRAM

SCALE: NONE CONTRACT NUMBER: PPI50969 PROJECT NUMBER: 8094

SHEET NUMBER: LA-P-131

not be reproduced, copied, loaned, exhibited, or used in any other way, except by written consent from PARSONS to the borrower.

This document and the design it covers are the property of PARSONS. They are loaned only with the borrower's expressed written agreement that they will

Sun Mar 23 08:47:56 1997 5:57:56 PM I:\LIGO\SITE2\MAX\lap131.ezd

E D C B A LIGOLAF.BDR